 
 
 
 







DHHR RESTROOMS
ONE DAVIS
BUILDING #36
 1 DAVIS SQUARE
 CHARLESTON, WEST VIRGINIA 25301

CEILING SYMBOL LEGEND

-  1' x 4' FLOURESCENT FIXTURE
-  1' x 2' FLOURESCENT FIXTURE
-  HVAC SUPPLY
-  HVAC EXHAUST
-  6" CAN LIGHT
-  SPRINKLER HEAD

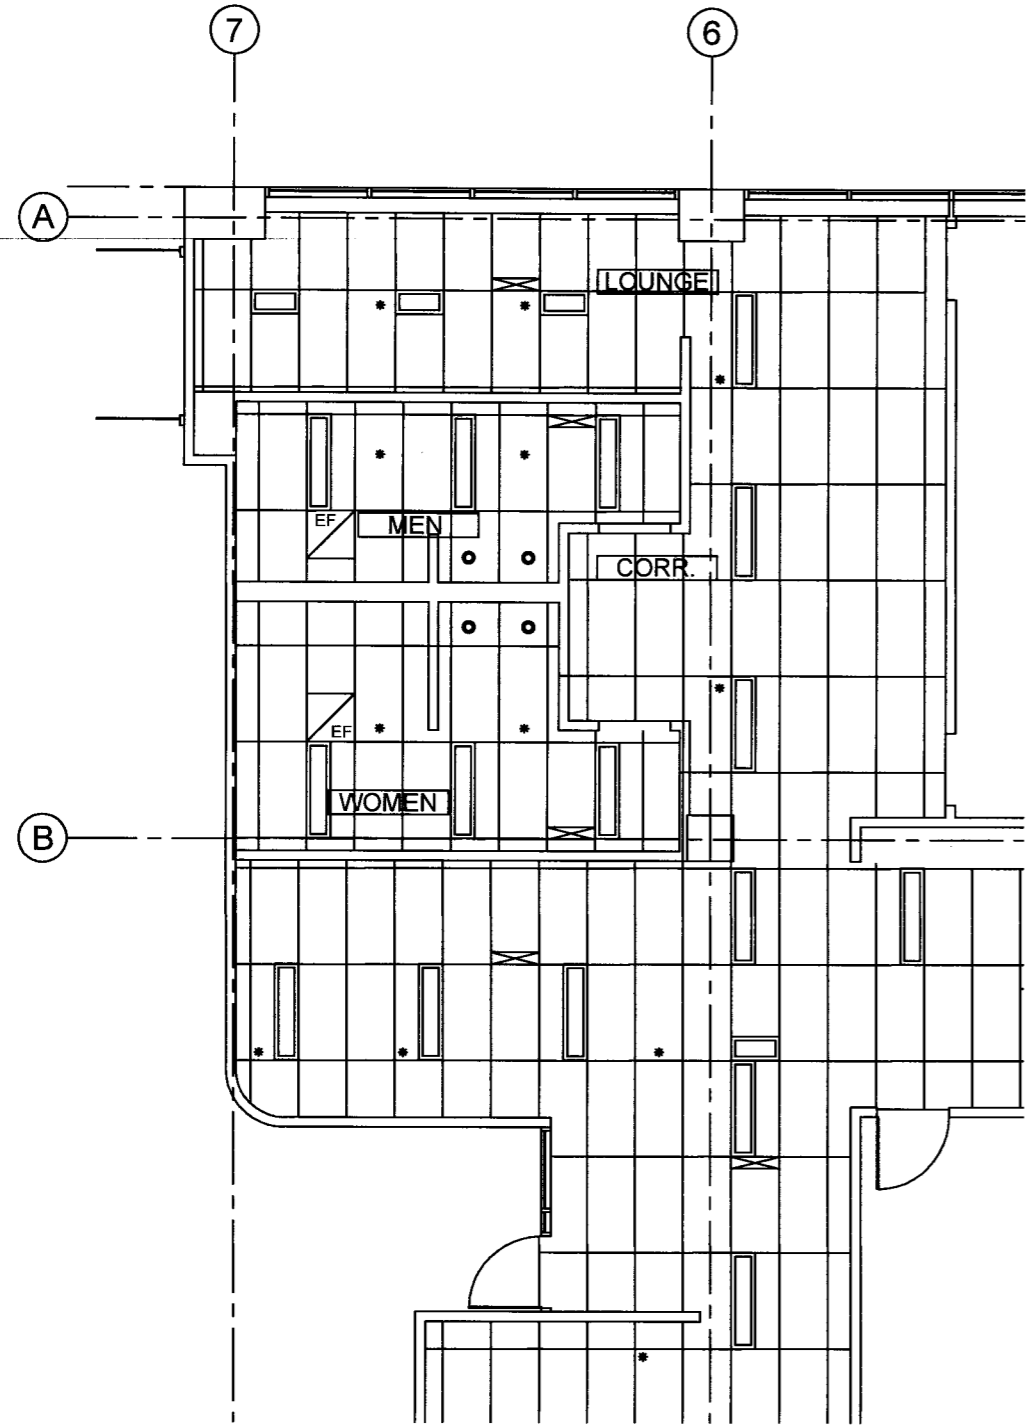

1 REFLECTED CEILING PLAN
 Scale: 1/8" = 1'-0"

REVISIONS	
DATE	NO.

SEAL

REVISED	
DATE	SCALE
08/05/10	NOTED
DRAWN BY	CHK. BY
MQE	

DRAWING NUMBER
A2