


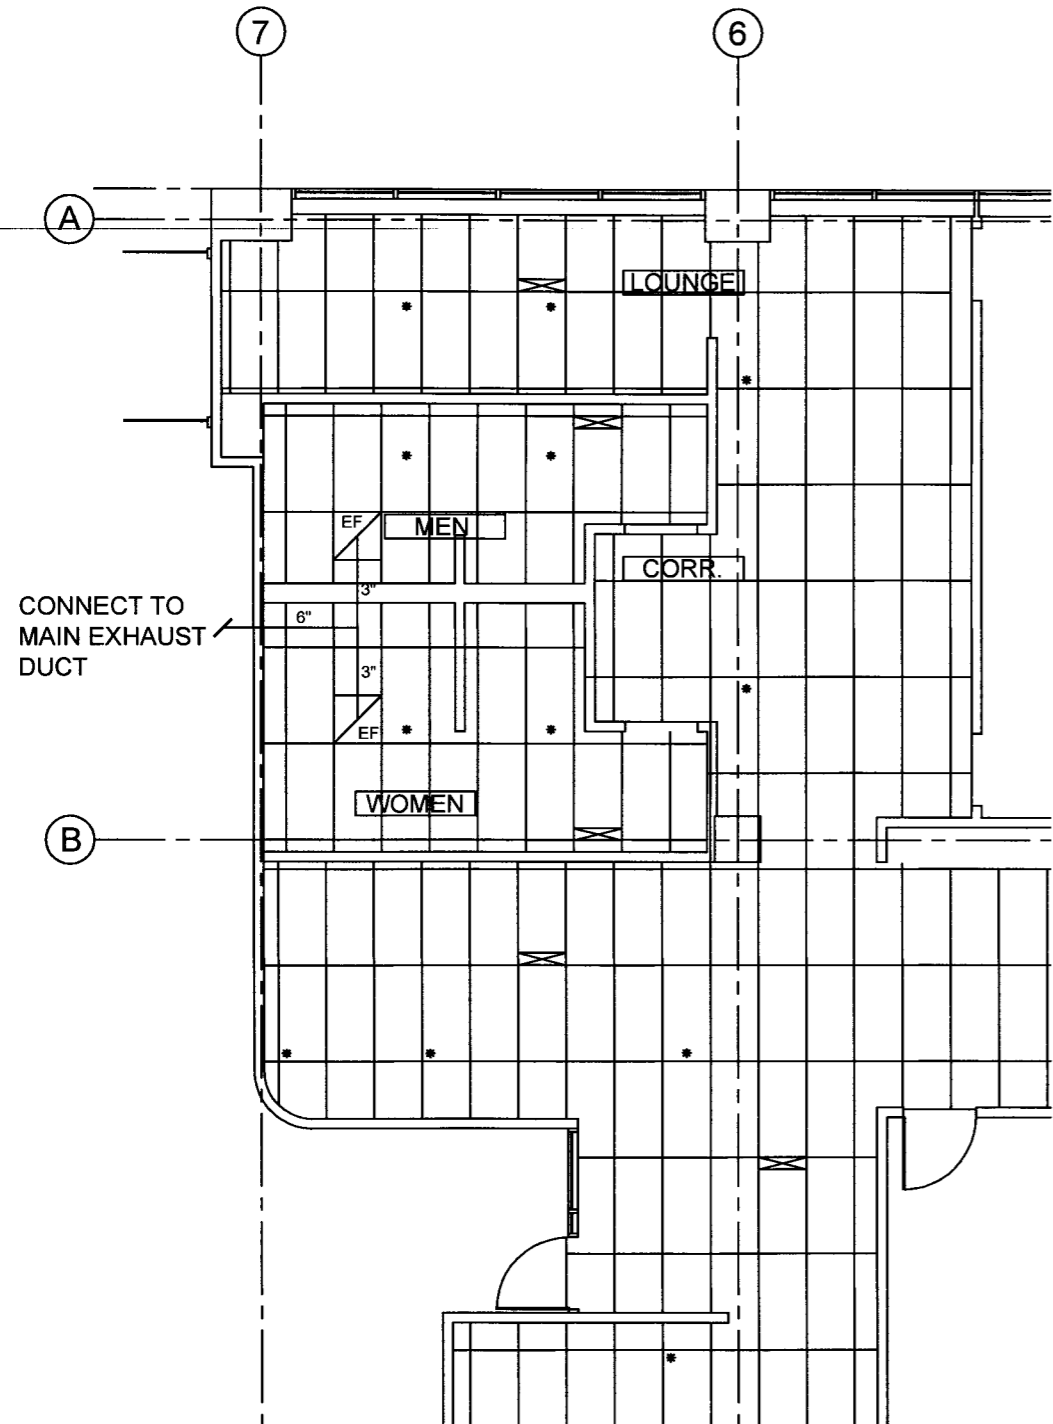




# MECHANICAL SYMBOL LEGEND

-  HVAC SUPPLY
-  HVAC EXHAUST
-  SPRINKLER HEAD



**1** MECHANICAL PLAN  
Scale: 1/8" = 1'-0"

**DHHR RESTROOMS**  
**ONE DAVIS**  
**BUILDING #36**  
 1 DAVIS SQUARE  
 CHARLESTON, WEST VIRGINIA 25301

REVISIONS	
DATE	NO.

SEAL

REVISED

DATE	SCALE
08/05/10	NOTED
DRAWN BY	CHK. BY
MQE	
DRAWING NUMBER	
<b>M1</b>	