


**DHHR RESTROOMS**  
**ONE DAVIS**  
**BUILDING #36**  
 1 DAVIS SQUARE  
 CHARLESTON, WEST VIRGINIA 25301

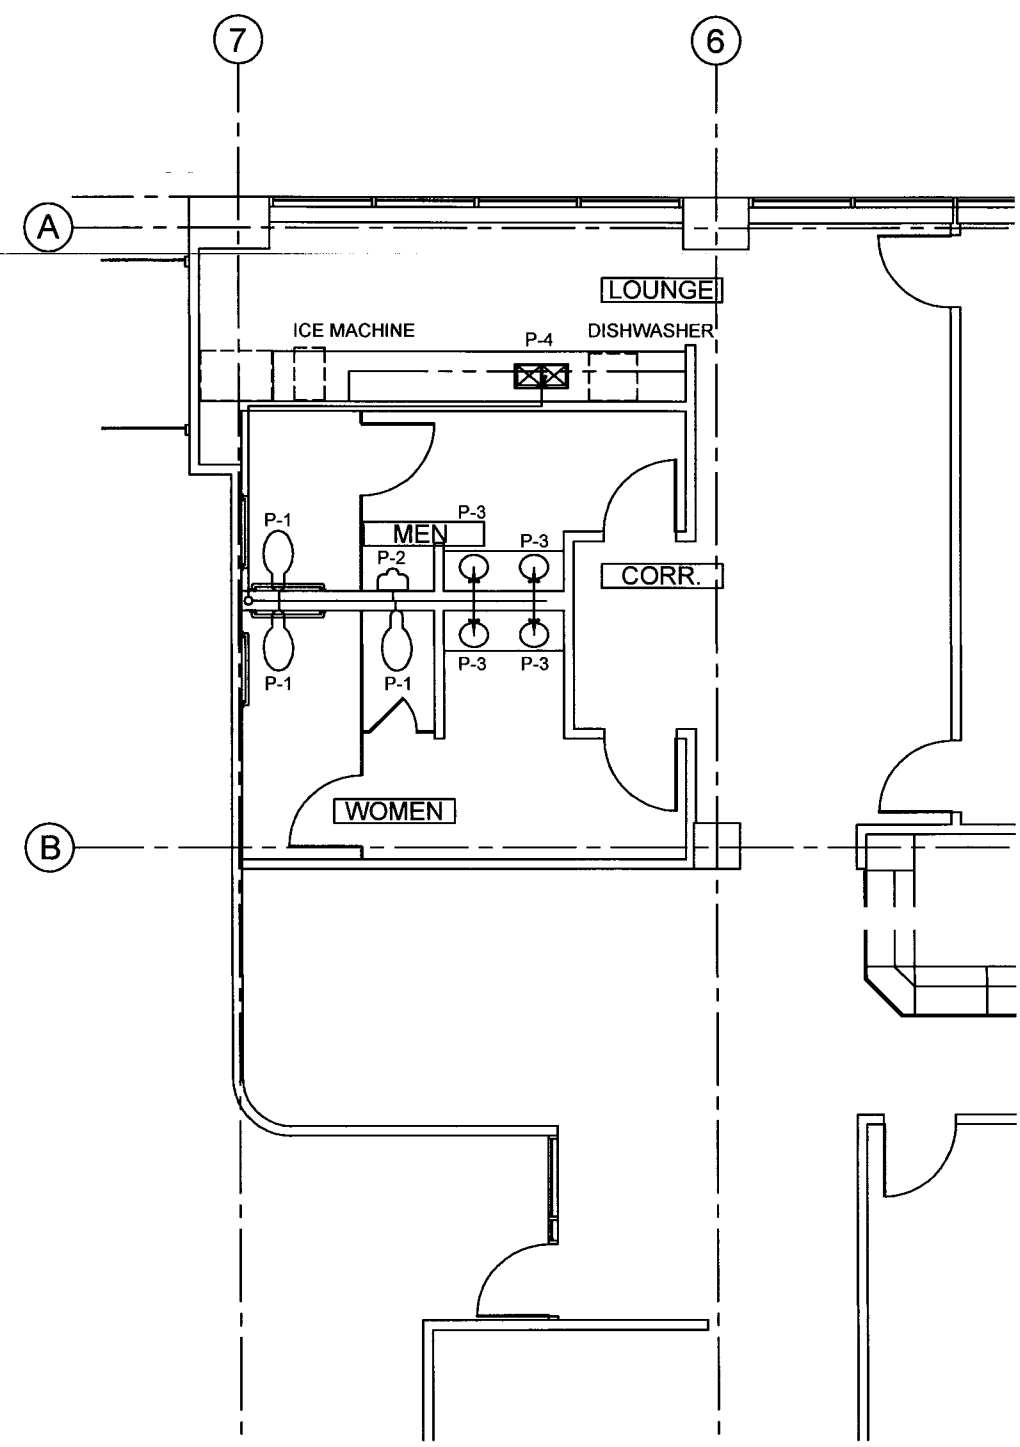

**1** **FIRST FLOOR PLUMBING PLAN**  
 Scale: 1/8" = 1'-0"

**PLUMBING NOTES**

1. SUPPLY AND SANITARY LINES TO BE STUBBED UP FROM NEAREST BASEMENT LOCATION. CONTRACTOR TO FIELD VERIFY TIE-IN LOCATIONS.
2. CONTRACTOR TO PROVIDE ISOLATION VALVES AT EACH FIXTURE AND AT TIE-IN LOCATIONS.
3. CONTRACTOR TO PROVIDE INSULATION SLEEVES ON WATER SUPPLY LINES.
4. CONTRACTOR TO PLUMB SUPPLY FOR DISHWASHER AND ICEMAKER PER EQUIPMENT SPECIFICATIONS.

**PLUMBING SPECIFICATIONS**

- P-1 CRANE ECO WHIRLTON - US3325  
 12" ROUGH-IN  
 8040 LIFT AND CLEAN SEAT  
 ZURN ZER6000AV-CPM FLUSH VALVE  
 COLOR: WHITE
- P-2 CRANE CROMWELL URINAL - 7397  
 17" MOUNTING HEIGHT (ADA)  
 ZURN ZER6003AV-CPM-WS1  
 COLOR: WHITE
- P-3 CRANE GALAXY OVAL SINK - US1287V  
 COLOR: WHITE  
 FAUCET: DELTA INNOVATIONS - 591-HGMHDF  
 FINISH: CHROME  
 BATTERY OPERATED
- P-4 ELKAY CELEBRITY DOUBLE BOWL SINK- CR3322  
 STAINLESS STEEL #20 GAUGE  
 3 HOLE  
 FAUCET: DELTA - 100-HDF-DST  
 FINISH: CHROME

**PLUMBING ACCESSORIES**

- TOILET PARTITIONS - GENERAL PARTITION MFG  
 STAINLESS STEEL  
 CHROME PLATED NON-FERROUS HARDWARE.
- GRAB BARS - BRADLEY  
 STAINLESS STEEL  
 36" MOUNTED HEIGHT (ADA)
- GLASS MIRROR -

\*NOTE: ALL TOILET ACCESSORIES NOT SHOWN ON PLANS OR ELEVATIONS: TOILET PAPER DISPENSER, FEMININE NAPKIN DISPENSER, SOAP DISPENSER, PAPER TOWEL DISPENSER WILL BE OWNER SUPPLIED, CONTRACTOR INSTALLED.

REVISIONS	
DATE	NO.

SEAL

REVISED	
DATE	SCALE
08/05/10	NOTED
DRAWN BY	CHK. BY
MQE	

DRAWING NUMBER  
**P1**