

ALPHA
ASSOCIATES, INCORPORATED
ARCHITECTS ENGINEERS SURVEYORS
209 PRAIRIE AVENUE
MORGANTOWN, WV 26501
PHONE: 304-296-8216
FAX: 304-296-8216
TOLL FREE: 800-640-8216
EMAIL: alpha@alphaoec.com
www.alphaoec.com

COPYRIGHT © 2010
ALPHA ASSOCIATES, INC.
ALL RIGHTS RESERVED

REVISIONS	
ITEM	DATE


EXISTING 3RD FLOOR PLAN

SCALE: AS NOTED

THE
CLARKSBURG STATE OFFICE BUILDING
WV GENERAL SERVICES DIVISION
PHASE ONE
CLARKSBURG, WEST VIRGINIA

DR'N.: KCB/RTL
P.M.: RJK P.I.C.: JAD
PROJ. NO.: 0810123.00
DATE: JULY 23, 2010
SHEET NO.:

A103

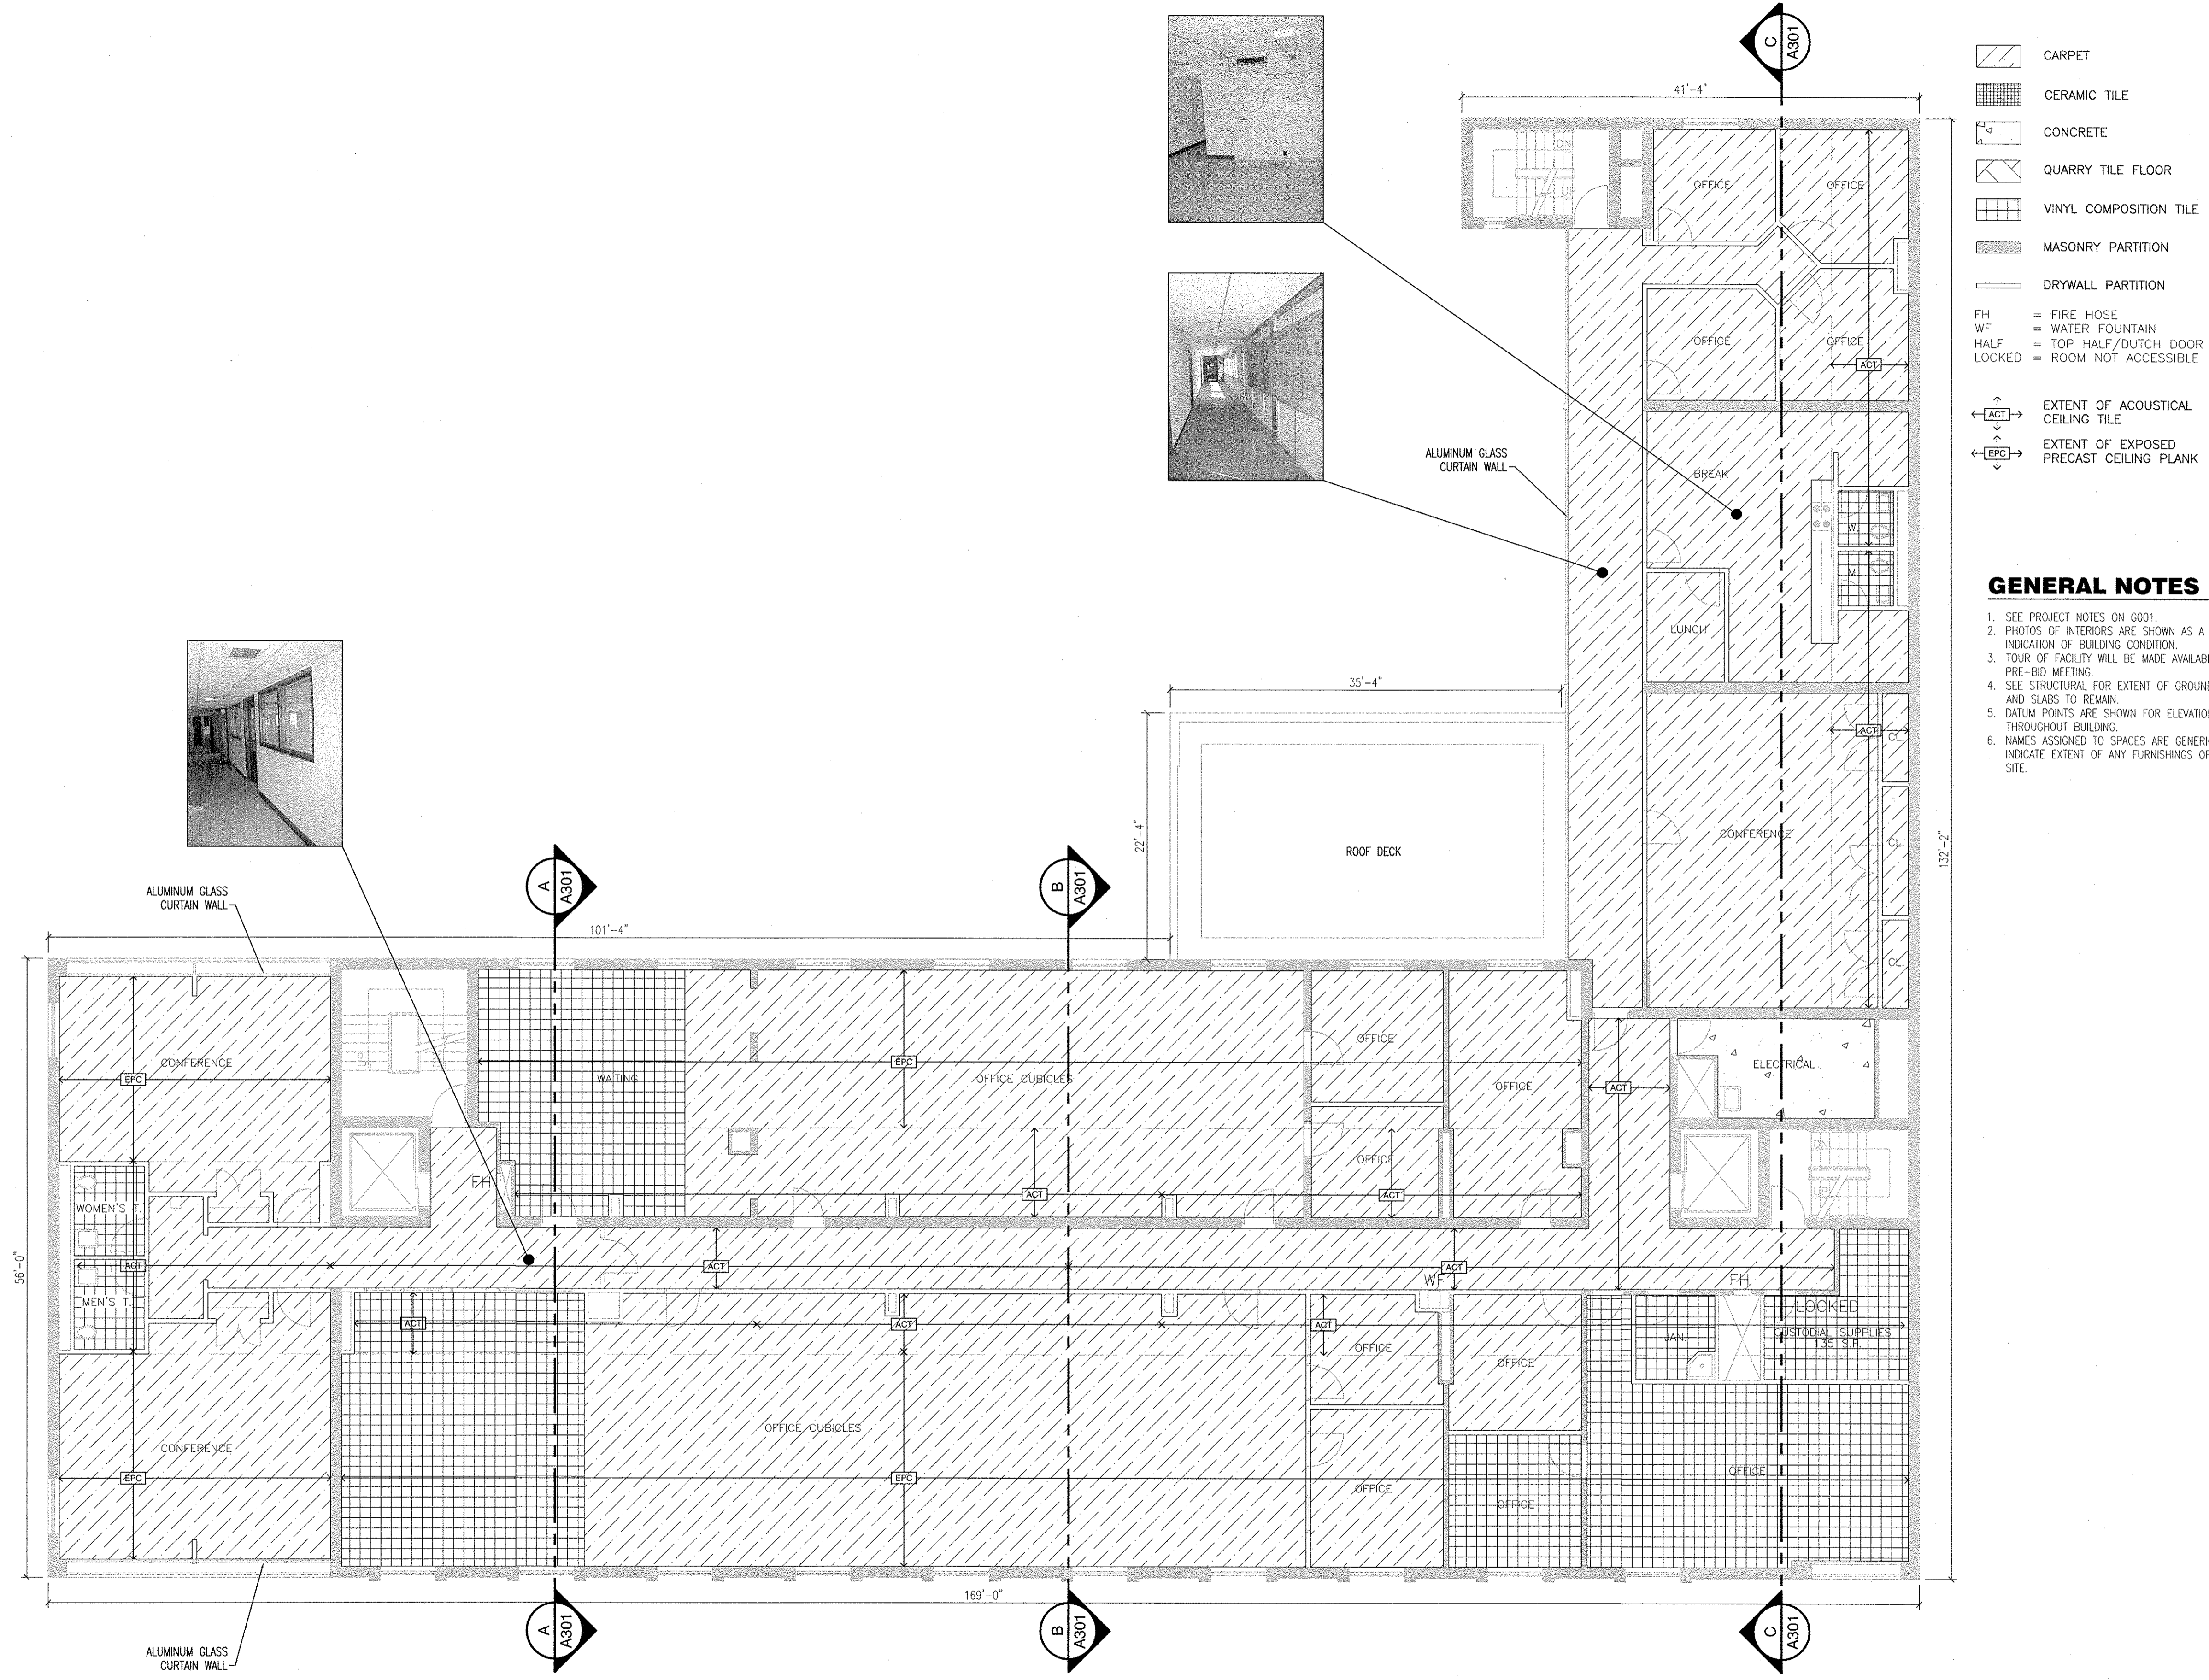

EXISTING 3RD FLOOR PLAN
SCALE: 1/8" = 1'-0"

