


I:\2011\2011227 Fairmont Office Building\DRAWINGS\ELEC\TECH\2011227 ES-0.1.dwg, SK-E2, 5/22/2013 11:31:53 AM, sbako, Bluebeam PDF - BW.pc3, ANSI_B (11.00_x_17.00_inches), 1:1, 00.final

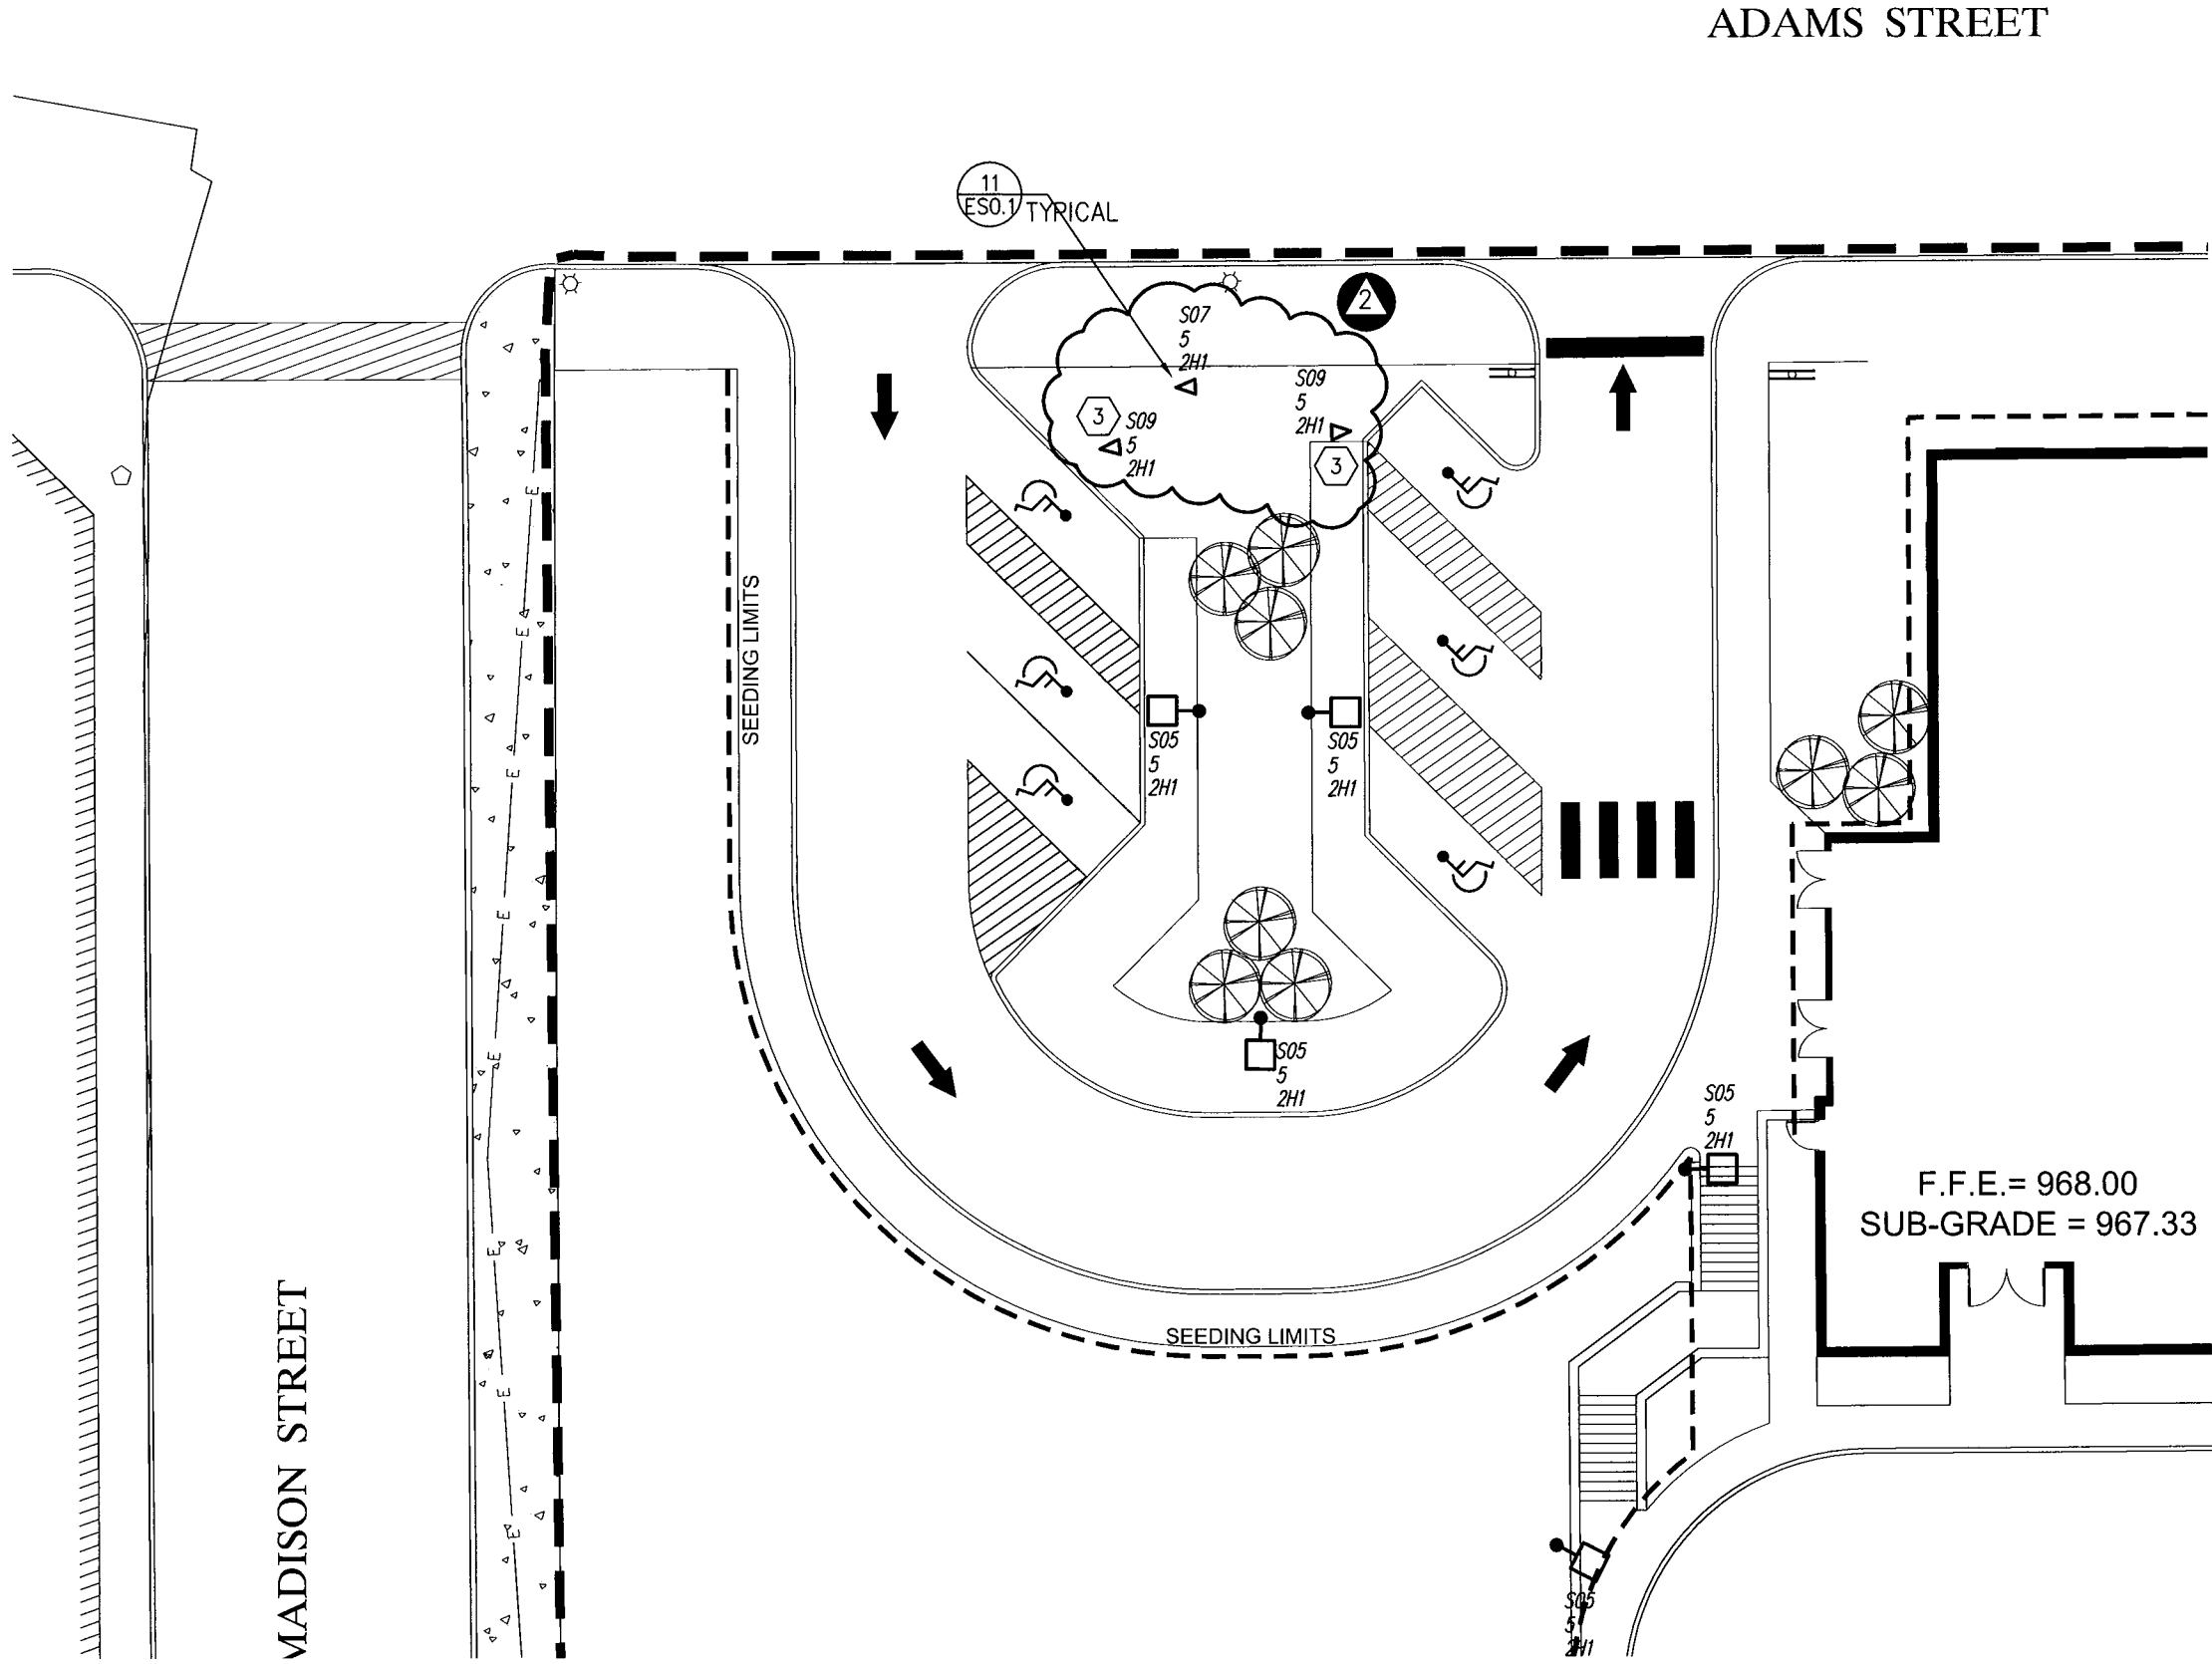

1
ES-0.1 **ELECTRICAL SITE PLAN - PARTIAL**
SCALE: 1" = 20'-0" REF. VIEW:

ATTACHMENT T

OAA
omni associates architects
(toll free) 855.367.1417
omni411.com

NEW STATE OFFICE BUILDING - FAIRMONT
PARTIAL ELECTRICAL SITE PLAN

DATE 05/17/13
PROJECT No. 21201 DRAWN BY: TSB
SK-E2
COPYRIGHT © ALL RIGHTS RESERVED. REPRODUCTION IN WHOLE OR IN PART IS PROHIBITED. THIS DRAWING IS AN INSTRUMENT OF SERVICE. IS THE PROPERTY OF THE ARCHITECT AND MAY NOT BE USED IN ANY WAY WITHOUT WRITTEN PERMISSION OF THIS FIRM.