

WILLIAM R. SHARPE HOSPITAL

50 Bed Addition

936 Sharpe Hospital Road
Weston, WV 26452-8550

West Virginia Department of Health and Human
Resources

Bid Set

November 14, 2012

PROJECT NUMBER 11-170

DRAWING INDEX



IKM
architecture
planning
interior design
IKM Incorporated
One PPG Place
Pittsburgh, PA 15222
412-281-1337

Contact: Jonathan Lusin

ZDS Design / Consulting Services

Mechanical, Electrical, and Plumbing
Contact: Jennings Davis

91 Smiley Drive
St. Albans, WV 25177
Phone: 304.755.0075

Allegheny Design Services

Structural
Contact: David Simpson

102 Leeway Street
Morgantown, WV 26505
Phone: 304.599.0771

Triad Engineering, Inc.

Civil Engineer / Site Survey
Contact: Lee McCoy

4980 Teays Valley Road
Scott Depot, WV 25560
Phone: 304.755.0721

30 January 2013 - Addendum #4	14 November 2012 - Bid Set	01 October 2012 - Permit Set	30 July 2012 - 100% Design Development	14 May 2012 - Schematic Design Set	SHEET NUMBER	SHEET NAME
-	-	-	-	-	C101	Existing Conditions
-	-	-	-	-	C102	Overall Site Plan
-	-	-	-	-	C103	Building Expansion Existing Conditions
-	-	-	-	-	C104	Building Expansion Demolition Plan
-	-	-	-	-	C105	Building Expansion Site / Layout Plan
-	-	-	-	-	C106	Building Expansion Grading and Drainage Plan
-	-	-	-	-	C106.1	Building Expansion Erosion and Sediment Control Plan
-	-	-	-	-	C107	Main Entrance Existing Conditions
-	-	-	-	-	C108	Main Entrance Demolition Plan
-	-	-	-	-	C109	Main Entrance Site / Layout Plan
-	-	-	-	-	C110	Main Entrance Grading and Drainage Plan
-	-	-	-	-	C111	Loading Dock Existing Conditions
-	-	-	-	-	C112	Loading Dock Demolition Plan
-	-	-	-	-	C113	Loading Dock Site and Layout Plan
-	-	-	-	-	C114	Loading Dock Grading and Drainage Plan
-	-	-	-	-	C115	Details
-	-	-	-	-	C116	Details
-	-	-	-	-	C117	Details
-	-	-	-	-	C118	Details

30 January 2013 - Addendum #4	14 November 2012 - Bid Set	01 October 2012 - Permit Set	30 July 2012 - 100% Design Development	14 May 2012 - Schematic Design Set	SHEET NUMBER	SHEET NAME
-	-	-	-	-	A000	General Notes, Partition Types, Schedules
-	-	-	-	-	AD100	Existing Building Demolition Plan - Level 1
-	-	-	-	-	AL100	Life Safety Plan - Level 1
-	-	-	-	-	AL101	Code Compliant Signage
-	-	-	-	-	AR100	Reference Plan - Level 1
-	-	-	-	-	AR101	Demensation Plan
-	-	-	-	-	A100	Existing Building - First Floor Plans
-	-	-	-	-	A100a	Partial Plan - Nursing Unit 1
-	-	-	-	-	A100b	Partial Plan - Nursing Unit 2
-	-	-	-	-	A100c	Partial Plan - Office and Sally Port
-	-	-	-	-	A101	Roof Plan
-	-	-	-	-	A200	Exterior Elevations
-	-	-	-	-	A201	Exterior Elevations
-	-	-	-	-	A202	Exterior Elevations
-	-	-	-	-	A203	Exterior Elevations
-	-	-	-	-	A204	Connection to Existing Building
-	-	-	-	-	A205	Existing Hospital - Exterior Loading Dock - Demolition
-	-	-	-	-	A206	Existing Hospital - Exterior Loading Dock
-	-	-	-	-	A207	Building Sections
-	-	-	-	-	A300	Building Sections
-	-	-	-	-	A300	Enlarged Plans
-	-	-	-	-	A301	Stair Plan, Sections and Details
-	-	-	-	-	A302	Enlarged Toilet Room Plans / Elevations
-	-	-	-	-	A303	Enlarged Toilet Room Plans / Elevations
-	-	-	-	-	A304	Enlarged Toilet Room Plans / Elevations
-	-	-	-	-	A400	Reflected Ceiling Reference Plan - Level 1
-	-	-	-	-	A400a	Enlarged Reflected Ceiling Plan
-	-	-	-	-	A400b	Enlarged Reflected Ceiling Plan
-	-	-	-	-	A400c	Enlarged Reflected Ceiling Plan
-	-	-	-	-	A500	Wall Sections / Exterior Details
-	-	-	-	-	A501	Wall Sections / Exterior Details
-	-	-	-	-	A502	Wall Sections / Exterior Details
-	-	-	-	-	A503	Wall Sections / Exterior Details
-	-	-	-	-	A504	Wall Sections / Exterior Details
-	-	-	-	-	A505	Exterior Details
-	-	-	-	-	A506	Exterior Details
-	-	-	-	-	A600	Interior Elevations
-	-	-	-	-	A601	Interior Elevations
-	-	-	-	-	A602	Interior Elevations & Sections - Dining
-	-	-	-	-	A603	Interior Elevations & Sections - Nurse Stations
-	-	-	-	-	A604	Interior Elevations & Sections - Social Nook
-	-	-	-	-	A605	Casework Sections
-	-	-	-	-	A606	Casework Sections
-	-	-	-	-	A607	Interior Details
-	-	-	-	-	A608	Door Schedule, Door and Frame Types and Details
-	-	-	-	-	A609	Window and Glazing Types and Schedules
-	-	-	-	-	A610	Window and Glazing Types and Schedules
-	-	-	-	-	A611	Window and Glazing Types and Schedules
-	-	-	-	-	AF100a	Finish Plan - Level 1 - Nursing Unit 1
-	-	-	-	-	AF100b	Finish Plan - Level 1 - Nursing Unit 2
-	-	-	-	-	AF100c	Finish Plan - Level 1 - Office and Sally Port
-	-	-	-	-	AF200	Finish Schedule - List of Materials
-	-	-	-	-	AF201	Finish Schedule - By Room
-	-	-	-	-	AF300a	Furniture Plan - Level 1 - Nursing Unit 1
-	-	-	-	-	AF300b	Furniture Plan - Level 1 - Nursing Unit 2
-	-	-	-	-	AF300c	Furniture Plan - Level 1 - Office and Sally Port
-	-	-	-	-	AF400	Interior Finish Details


30 January 2013 - Addendum #4	14 November 2012 - Bid Set	01 October 2012 - Permit Set	30 July 2012 - 100% Design Development	SHEET NUMBER	SHEET NAME
-	-	-	-	S001	General Notes
-	-	-	-	S010	Foundation Plan
-	-	-	-	S011	Typ. Foundation Details
-	-	-	-	S012	Foundation Details
-	-	-	-	S100	Ground Floor Plan
-	-	-	-	S120	Level 2 Framing Plan
-	-	-	-	S130	Courtyard's Overhang Framing
-	-	-	-	S400	Column Schedule
-	-	-	-	S401	Column Schedule
-	-	-	-	S500	Typ. Steel Details
-	-	-	-	S501	Steel Details
-	-	-	-	S502	Operable Partition Supports
-	-	-	-	S503	Masonry Details
-	-	-	-	S600	Sections and Elevations
-	-	-	-	S601	Sections and Elevations
-	-	-	-	S602	Sections and Elevations
-	-	-	-	S603	Sections and Elevations
-	-	-	-	S604	Sections and Elevations
-	-	-	-	S605	Exterior Elevations
-	-	-	-	S606	Wall Sections
-	-	-	-	S607	Wall Sections
-	-	-	-	S608	Loading Dock Details
-	-	-	-	SKC-1	Additional Laydown Area
-	-	-	-	SKC-2	Detail WC 115
-	-	-	-	SKC-3	Main Entrance Parking
-	-	-	-	SKC-4	Gas Line - Future Connection
-	-	-	-	SKE-1	Partial Site Plan
-	-	-	-	SKE-2	Revised Electrical Room
-	-	-	-	SKE-3	Transformer Enclosure

30 January 2013 - Addendum #4	Sketch Number	Sketch Name
-	SKC-1	Additional Laydown Area
-	SKC-2	Detail WC 115
-	SKC-3	Main Entrance Parking
-	SKC-4	Gas Line - Future Connection
-	SKE-1	Partial Site Plan
-	SKE-2	Revised Electrical Room
-	SKE-3	Transformer Enclosure

30 January 2013 - Addendum #4	14 November 2012 - Bid Set	01 October 2012 - Permit Set	30 July 2012 - 100% Design Development	SHEET NUMBER	SHEET NAME
-	-	-	-	M001	Mechanical Symbols, Abbreviations and Notes
-	-	-	-	MEPI01	Roof Plan
-	-	-	-	MEPI02	Loading Dock Demolition and New Work Plans
-	-	-	-	M101	Nursing Unit 1 - HVAC Supply Ductwork
-	-	-	-	M102	Nursing Unit 1 - HVAC Return & Exhaust Ductwork
-	-	-	-	M103	Nursing Unit 2 - HVAC Supply Ductwork
-	-	-	-	M104	Nursing Unit 2 - HVAC Return & Exhaust Ductwork
-	-	-	-	M105	Office and Sally Port - HVAC Supply Ductwork
-	-	-	-	M106	Office and Sally Port - HVAC Return & Exhaust Ductwork
-	-	-	-	M201	Nursing Unit 1 - HVAC Piping
-	-	-	-	M202	Nursing Unit 2 - HVAC Piping
-	-	-	-	M203	Office And Sally Port - HVAC Piping
-	-	-	-	M204	Enlarged Plumbing Plans
-	-	-	-	M401	Plumbing Details
-	-	-	-	M402	Plumbing Details
-	-	-	-	M403	Plumbing Details
-	-	-	-	M404	Enlarged Floor Plans
-	-	-	-	M401	HVAC Details
-	-	-	-	M402	HVAC Details
-	-	-	-	M403	AHU Details
-	-	-	-	M501	HVAC Controls
-	-	-	-	M502	HVAC Controls
-	-	-	-	M601	HVAC Schedules
-	-	-	-	M602	HVAC Schedules

30 January 2013 - Addendum #4	14 November 2012 - Bid Set	01 October 2012 - Permit Set	30 July 2012 - 100% Design Development	SHEET NUMBER	SHEET NAME
-	-	-	-	PD104	Partial First Floor - Plumbing Demolition Plan
-	-	-	-	P101	Nursing Unit 1 - Sanitary & Vent Plumbing Plan
-	-	-	-	P102	Nursing Unit 2 - Sanitary & Vent Plumbing Plan
-	-	-	-	P103	Office and Sally Port - Sanitary & Vent Plumbing Plan
-	-	-	-	P104	Partial First Floor - Plumbing Plan
-	-	-	-	P105	Roof Plan - Roof Drainage Systems
-	-	-	-	P201	Nursing Unit 1 - Domestic Water
-	-	-	-	P202	Nursing Unit 2 - Domestic Water
-	-	-	-	P203	Office and Sally Port - Domestic Water
-	-	-	-	P204	Enlarged Plumbing Plans
-	-	-	-	P401	Plumbing Details
-	-	-	-	P402	Plumbing Details
-	-	-	-	P501	Plumbing Schedules

30 January 2013 - Addendum #4	14 November 2012 - Bid Set	01 October 2012 - Permit Set	30 July 2012 - 100% Design Development	SHEET NUMBER	SHEET NAME
-	-	-	-	E001	Electrical Symbols, Abbreviations, and Notes
-	-	-	-	E3101	Electrical - Site Plan
-	-	-	-	E101	Nursing Unit 2 - Lighting and Systems
-	-	-	-	E102	Nursing Unit 1 - Lighting and Systems
-	-	-	-	E103	Office and Sally Port - Lighting
-	-	-	-	E201	Nursing Unit 1 - Power Plan
-	-	-	-	E202	Nursing Unit 2 - Power Plan
-	-	-	-	E203	Office and Sally Port - Power Plan
-	-	-	-	E301	Nursing Unit 1 - Electrical Systems Plan
-	-	-	-	E302	Nursing Unit 2 - Electrical Systems Plan
-	-	-	-	E303	Office and Sally Port - Electrical Systems Plan
-	-	-	-	E304	IT / Data / Telephone Cabling in Existing Hospital Building
-	-	-	-	E401	Electrical Details
-	-	-	-	E402	Electrical Details
-	-	-	-	E403	Lighting Protection System Details
-	-	-	-	E404	Lighting Protection System Details
-	-	-	-	E405	Electrical Schematics
-	-	-	-	E406	Electrical Schematics
-	-	-	-	E501	Electrical Schedules and Schematic
-	-	-	-	E502	Electrical Panel Schedules
-	-	-	-	E503	Electrical Panel Schedules
-	-	-	-	E601	Roof Plan - Lightning Protection System

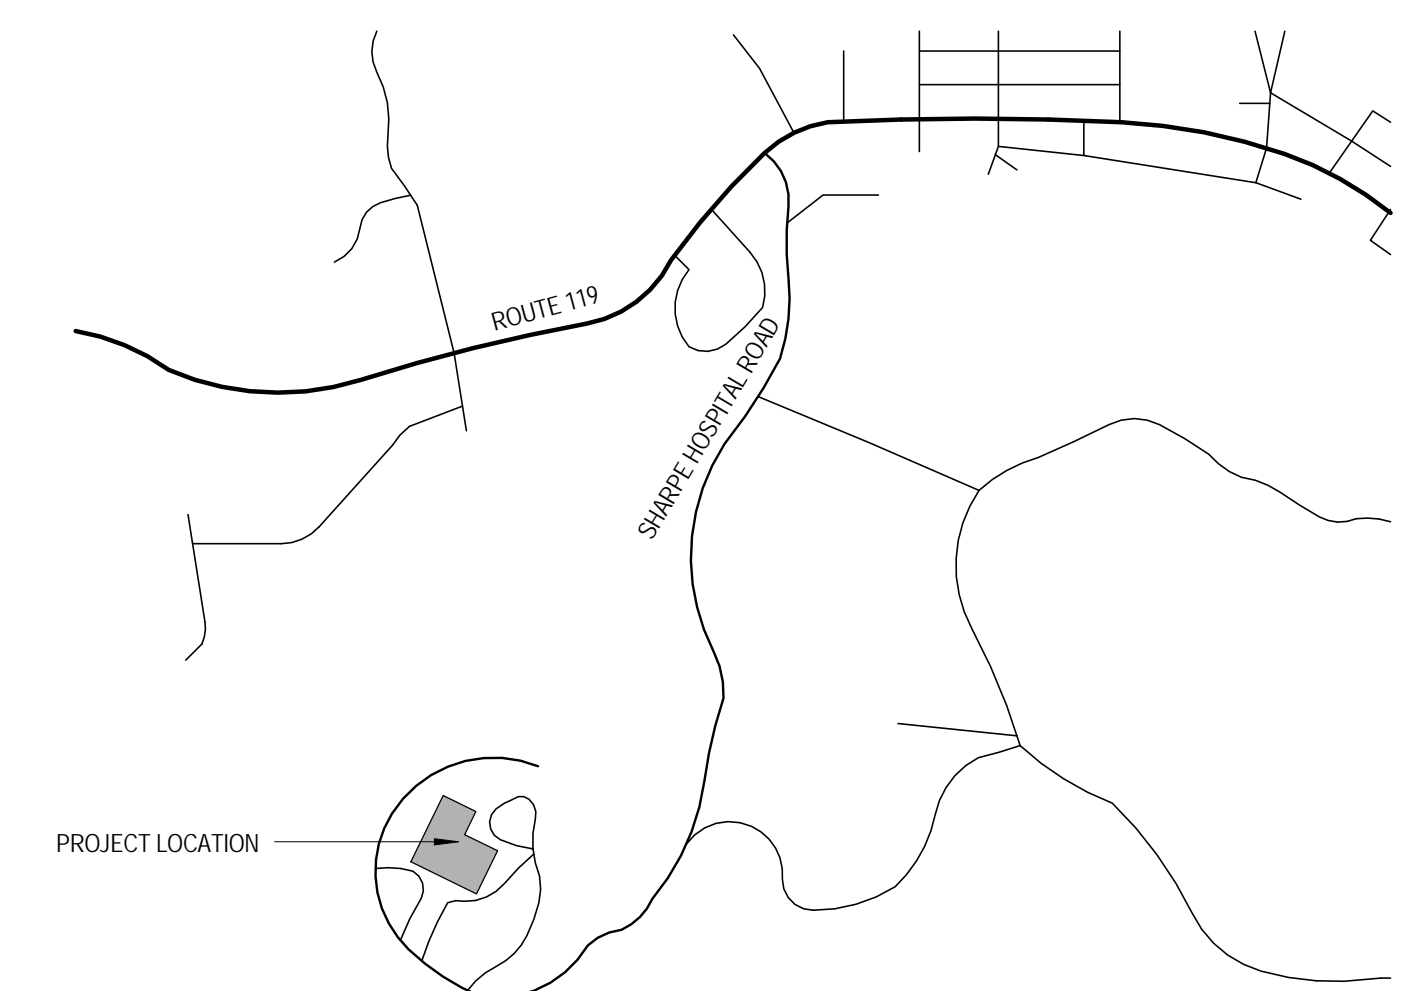

BUILDING LOCATION PLAN