

**PARKING LOT PHASING**  
 THE FOLLOWING PHASING SHOULD BE USED DURING PARKING LOT CONSTRUCTION.

**PHASE 1**  
 EXISTING PARKING LOT TO REMAIN OPEN WHILE CONTRACTOR CONSTRUCTS EXPANSION. MAINTAIN 2' BUFFER BETWEEN EXISTING AND NEW PARKING AREAS.

**PHASE 2**  
 ONCE GRADING, BASE STONE AND BASE COURSE ASPHALT HAVE BEEN INSTALLED IN NEW AREAS, CLOSE EXISTING LOT FOR CLEANING, PATCHING AS NECESSARY AND GRADING.

**PHASE 3**  
 ON WEEKENDS OVERLAY ENTIRE PARKING LOT WITH WEAR COURSE. ONCE ASPHALT HAS ADEQUATELY CURED STRIPE ENTIRE NEW LOT.

LEGEND	
EXISTING	
	STORM DRAIN
	SANITARY SEWER
	DROP INLET
	GAS UTILITY MARKER
	SANITARY MANHOLE
	LIGHT POST
	WATER VALVE
	WATER METER
	POWER POLE
	TELEPHONE PEDESTAL
	FIRE HYDRANT
	SCORE JOINTS
	TRENCH DRAIN
	WATER LINE
	GAS LINE
	SEWER LINE
	DESIGN CONTOURS
	DESIGN SPOT ELEVATIONS
	SILT FENCE
	GUARDRAIL
	DOUBLE POST SIGN
	SIGN
	TELEPHONE/CABLE/POWER/LIGHT POLE
	TELEPHONE/ELECTRIC
	TELEPHONE/CABLE
	GUY WIRE
	GUY POLE
	UNDERGROUND E-T-C
	DETAIL BUBBLE REFERENCE
	INLET PROTECTION BERM


**SITE LIGHTING- SEE ELECTRICAL PLANS FOR DETAILS.**

ALL POLES @ 25' HIGH.  
 13 POLES TOTAL  
 3 POLES W/SINGLE FIXTURE  
 10 W/DUAL FIXTURES.  
 VARIOUS DISTRIBUTIONS  
 23 FIXTURES TOTAL

(2) LUMINARIE DISTRIBUTION TYPE II.  
 (3) LUMINARIE DISTRIBUTION TYPE III.  
 (4) LUMINARIE DISTRIBUTION TYPE V.

**IKM**  
 architecture  
 planning  
 interior design  
 IKM Incorporated  
 One PPG Place  
 Pittsburgh, PA 15222

**TRIAD**  
 TRIAD ENGINEERING, INC.  
 4880 TEAYS VALLEY ROAD  
 SCOTT DEPOT, WV 26060  
 PH: 304.753.0721 FAX: 304.755.1880

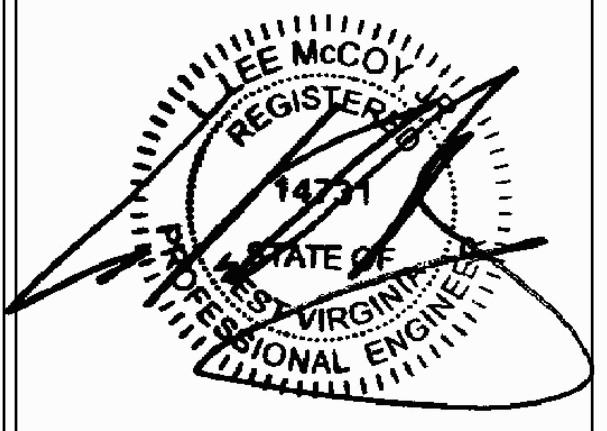

Project North True North

**Bid Set**

No.	Date	Description
01-30-2013		Addendum #4

Revisions

Date  
 14 November 2012

Project Title  
**William R. Sharpe  
 Hospital  
 50 Bed Addition**

936 Sharpe Hospital Road  
 Weston, WV 26452-8550

Drawing Title  
**BUILDING  
 EXPANSION SITE /  
 LAYOUT PLAN**

Project Number  
 11-170

Drawing Number  
**C105**



DRAWING SCALE: 1"=20'