



STATE DIST. NO.	STATE PROJECT NUMBER	FEDERAL PROJECT NUMBER	FISCAL YEAR	COUNTY	SHEET NO.	TOTAL SHEETS
WV	G020 HDQ/6.07	-	2013	KANAWHA	96	108

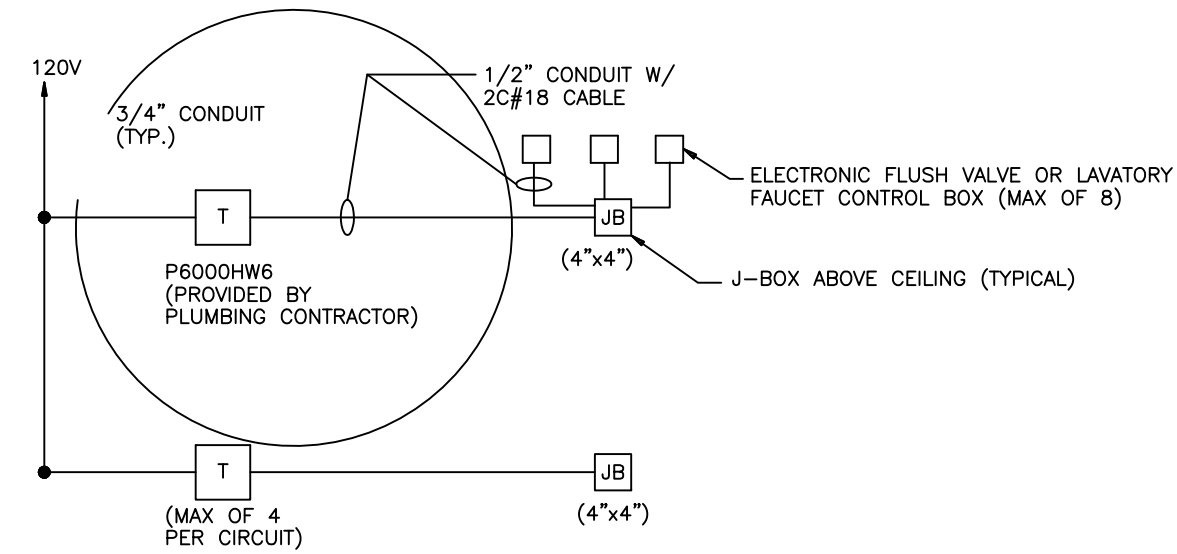

**ELECTRONIC FAUCET AND FLUSH VALVE RISER**

SCALE: N/A

- PLAN NOTES:**
- (A) SEE FIRE ALARM/ELECTRICAL/SPRINKLER REQUIREMENTS FOR ELEVATOR ON SHEET E14.
  - (B) SEE TELEPHONE/DATA RISER ON SHEET E6.
  - (C) LIFT STATION CONTROL PANEL. SEE SHEET P5 FOR DETAILS.
  - (D) PROVIDE 3P/100A FUSED DISCONNECT SWITCH WITH SHUNT TRIP. COORDINATE FUSE SIZES WITH ELEVATOR EQUIPMENT MANUFACTURER.
  - (E) TRANSFORMER ABOVE CEILING FOR FLUSH VALVES AND FAUCETS. ELECTRICAL CONTRACTOR TO INSTALL ALL WIRING AND MAKE ALL CONNECTIONS. SEE ELECTRONIC FAUCET AND FLUSH VALVE RISER THIS SHEET. PLUMBING CONTRACTOR TO SUPPLY TRANSFORMER.
  - (F) DIRECT CONNECTION FOR ELECTRIC HAND DRYER.
  - (G) VFD PROVIDED BY MECHANICAL CONTRACTOR AND INSTALLED BY ELECTRICAL CONTRACTOR.
  - (H) COORDINATE INSTALLATION WITH DOOR MANUFACTURER.

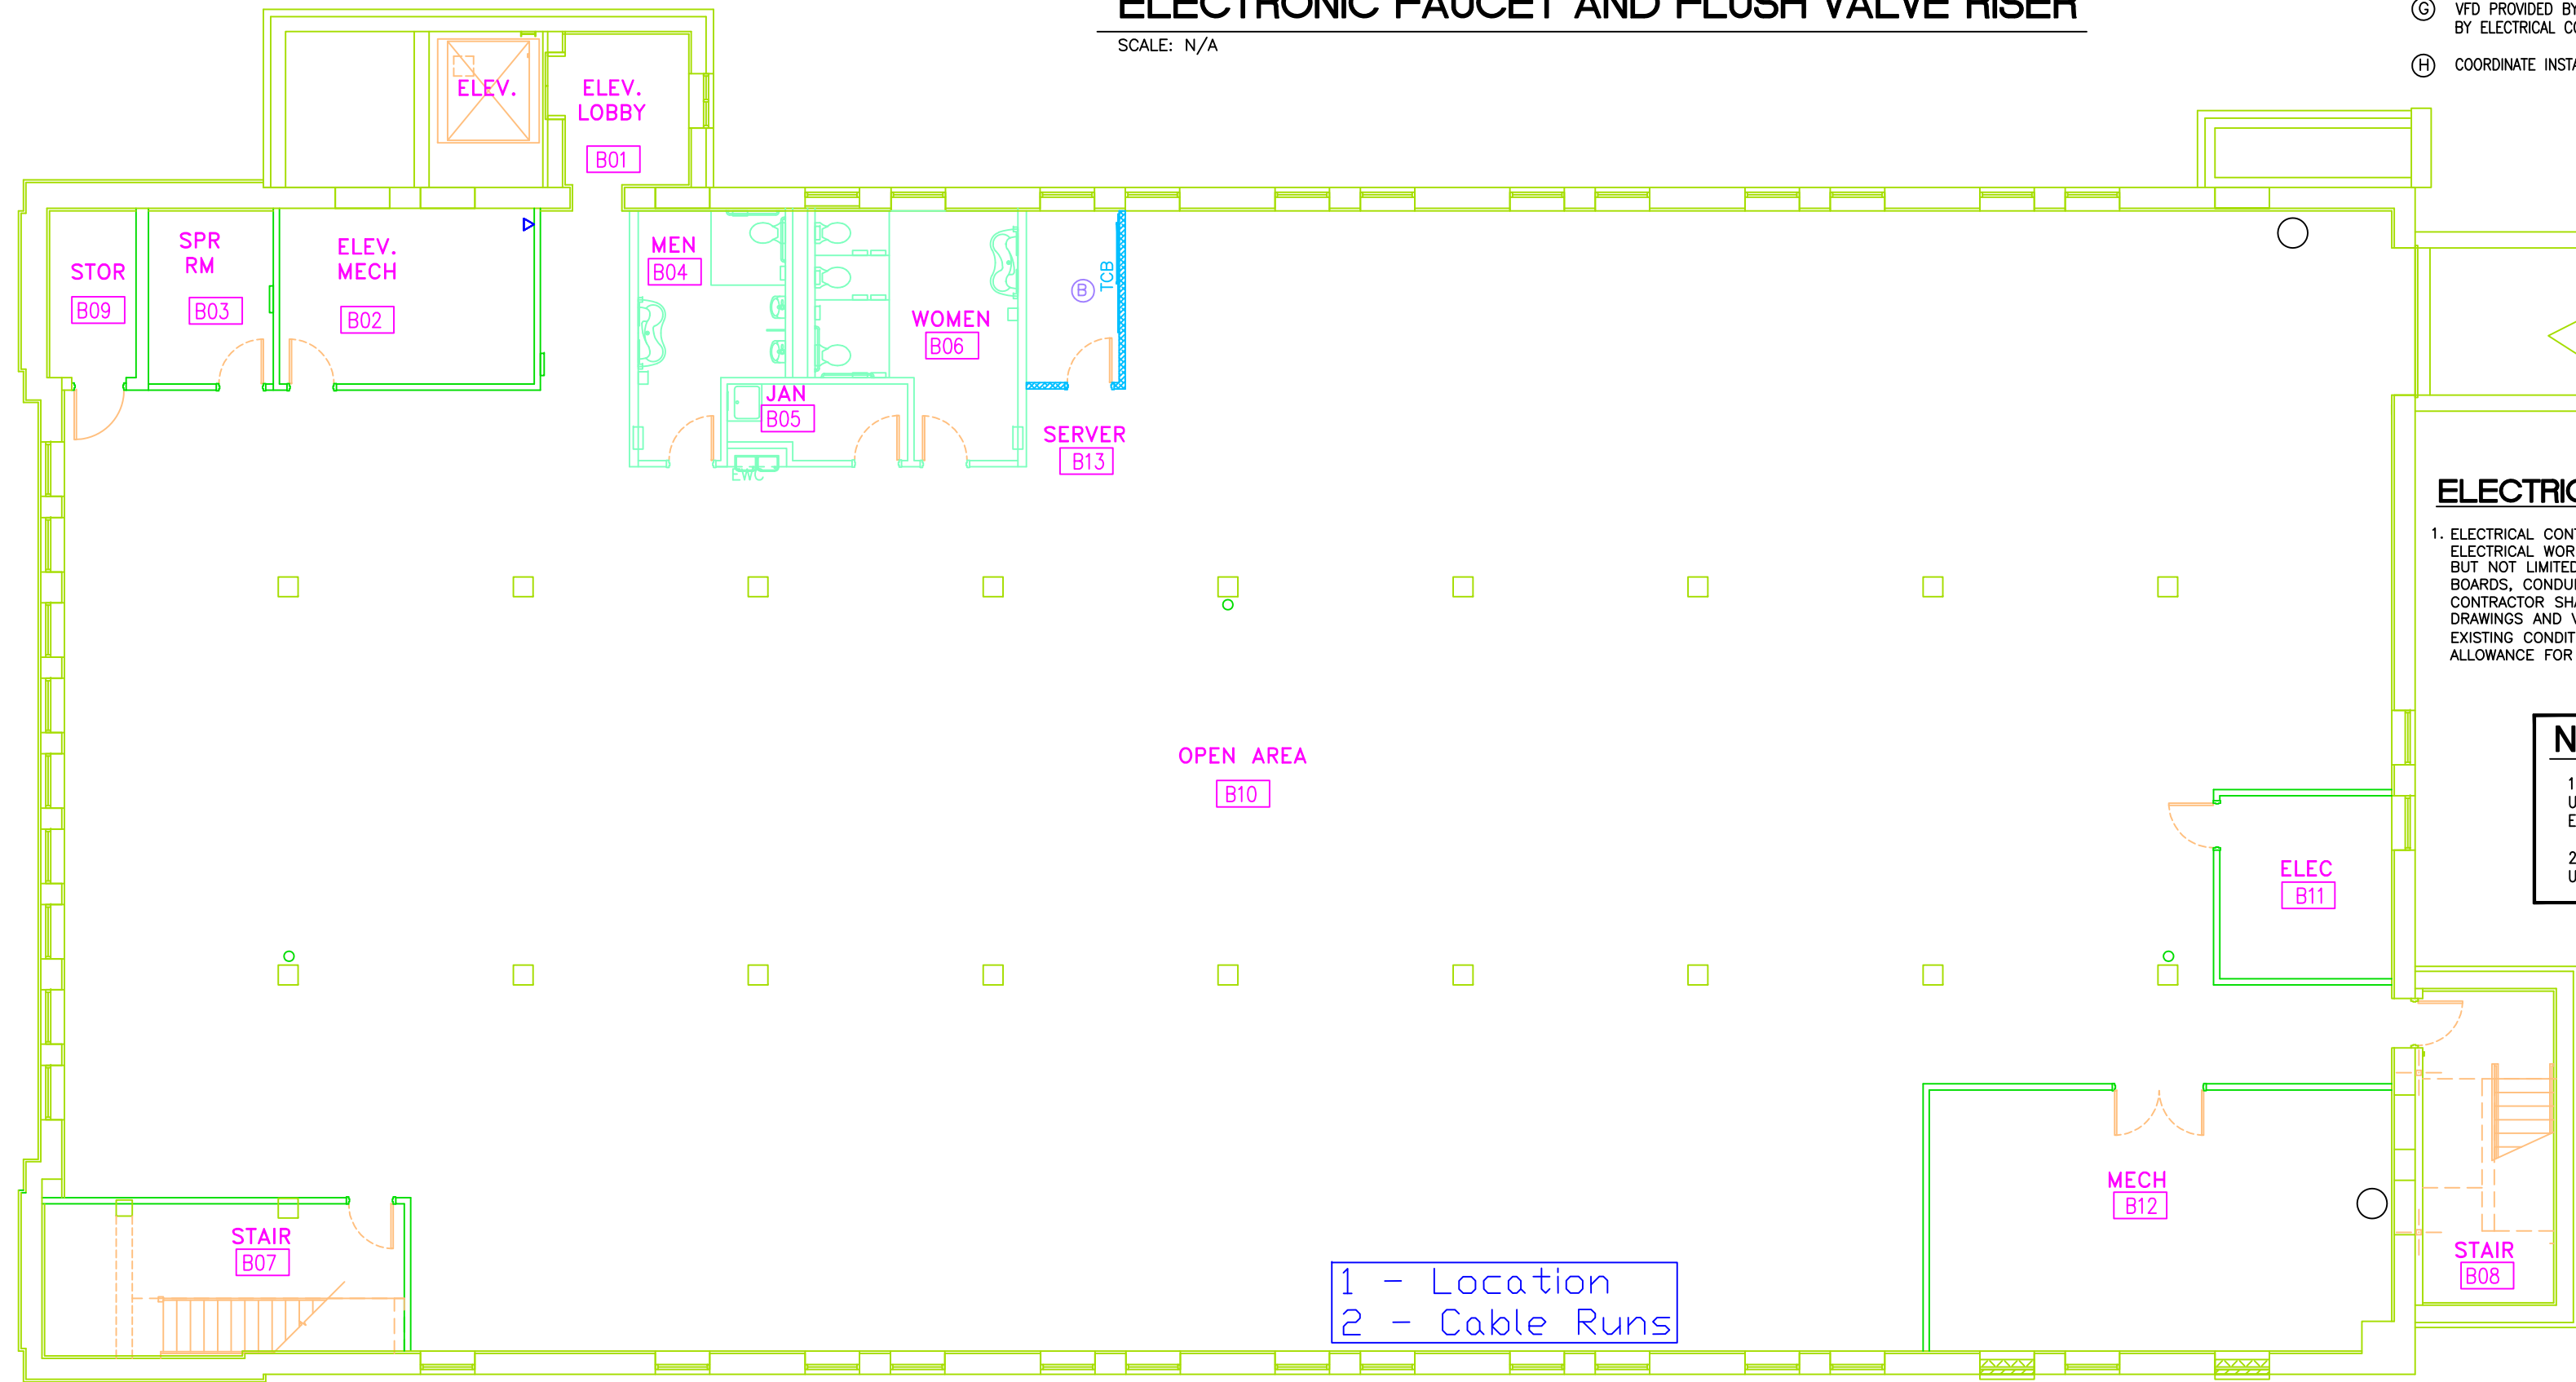

**ELECTRICAL DEMO NOTES**

1. ELECTRICAL CONTRACTOR SHALL DISCONNECT AND REMOVE ALL ELECTRICAL WORK NOT INDICATED TO REMAIN. THIS INCLUDES BUT NOT LIMITED TO LIGHTING FIXTURES, RECEPTACLES, PANEL BOARDS, CONDUIT, JUNCTION BOXES AND WIRING. CONTRACTOR SHALL COORDINATE WITH ARCHITECTURAL DRAWINGS AND VISIT THE SITE PRIOR TO BIDDING, DETERMINE EXISTING CONDITIONS, EXTENT OF REMOVAL WORK AND MAKE ALLOWANCE FOR SUCH WORK.

**NOTES:**

1. ALL CONDUIT ENTERING BUILDING FROM UNDERGROUND SHALL TURN UP INSIDE OF EXTERIOR WALL TO CEILING ABOVE.
2. RECEPTACLES IN EXISTING WALLS SHALL USE SHALLOW OUTLET BOXES.

DOT-DOH-District 1  
HQ SRC Building  
**BASEMENT POWER PLAN**  
SCALE: 1/8" = 1'-0"



Designed By: JEH  
Checked By: JEH  
Drawn By: STAFF  
Job No.: 12007  
Scale: AS NOTED  
Date: SEPTEMBER 2012

**Chapman Technical Group**  
ENGINEERS • ARCHITECTS • INTERIOR DESIGNERS • LANDSCAPE ARCHITECTS  
P.O. Box 1325, St. Albans, West Virginia (304) 727-5501  
P.O. Box 229, Buckhannon, West Virginia (304) 472-8914

REVISION NUMBER	REVISIONS	DATE	BY

WEST VIRGINIA DEPARTMENT OF TRANSPORTATION  
DIVISION OF HIGHWAYS  
SRC BUILDING RENOVATIONS  
STATE PROJECT TBD

BASEMENT POWER PLAN  
SHEET NO. E4