




1 ELECTRICAL BASEMENT FLOOR PLAN - POWER
SCALE: 1/8" = 1'-0"

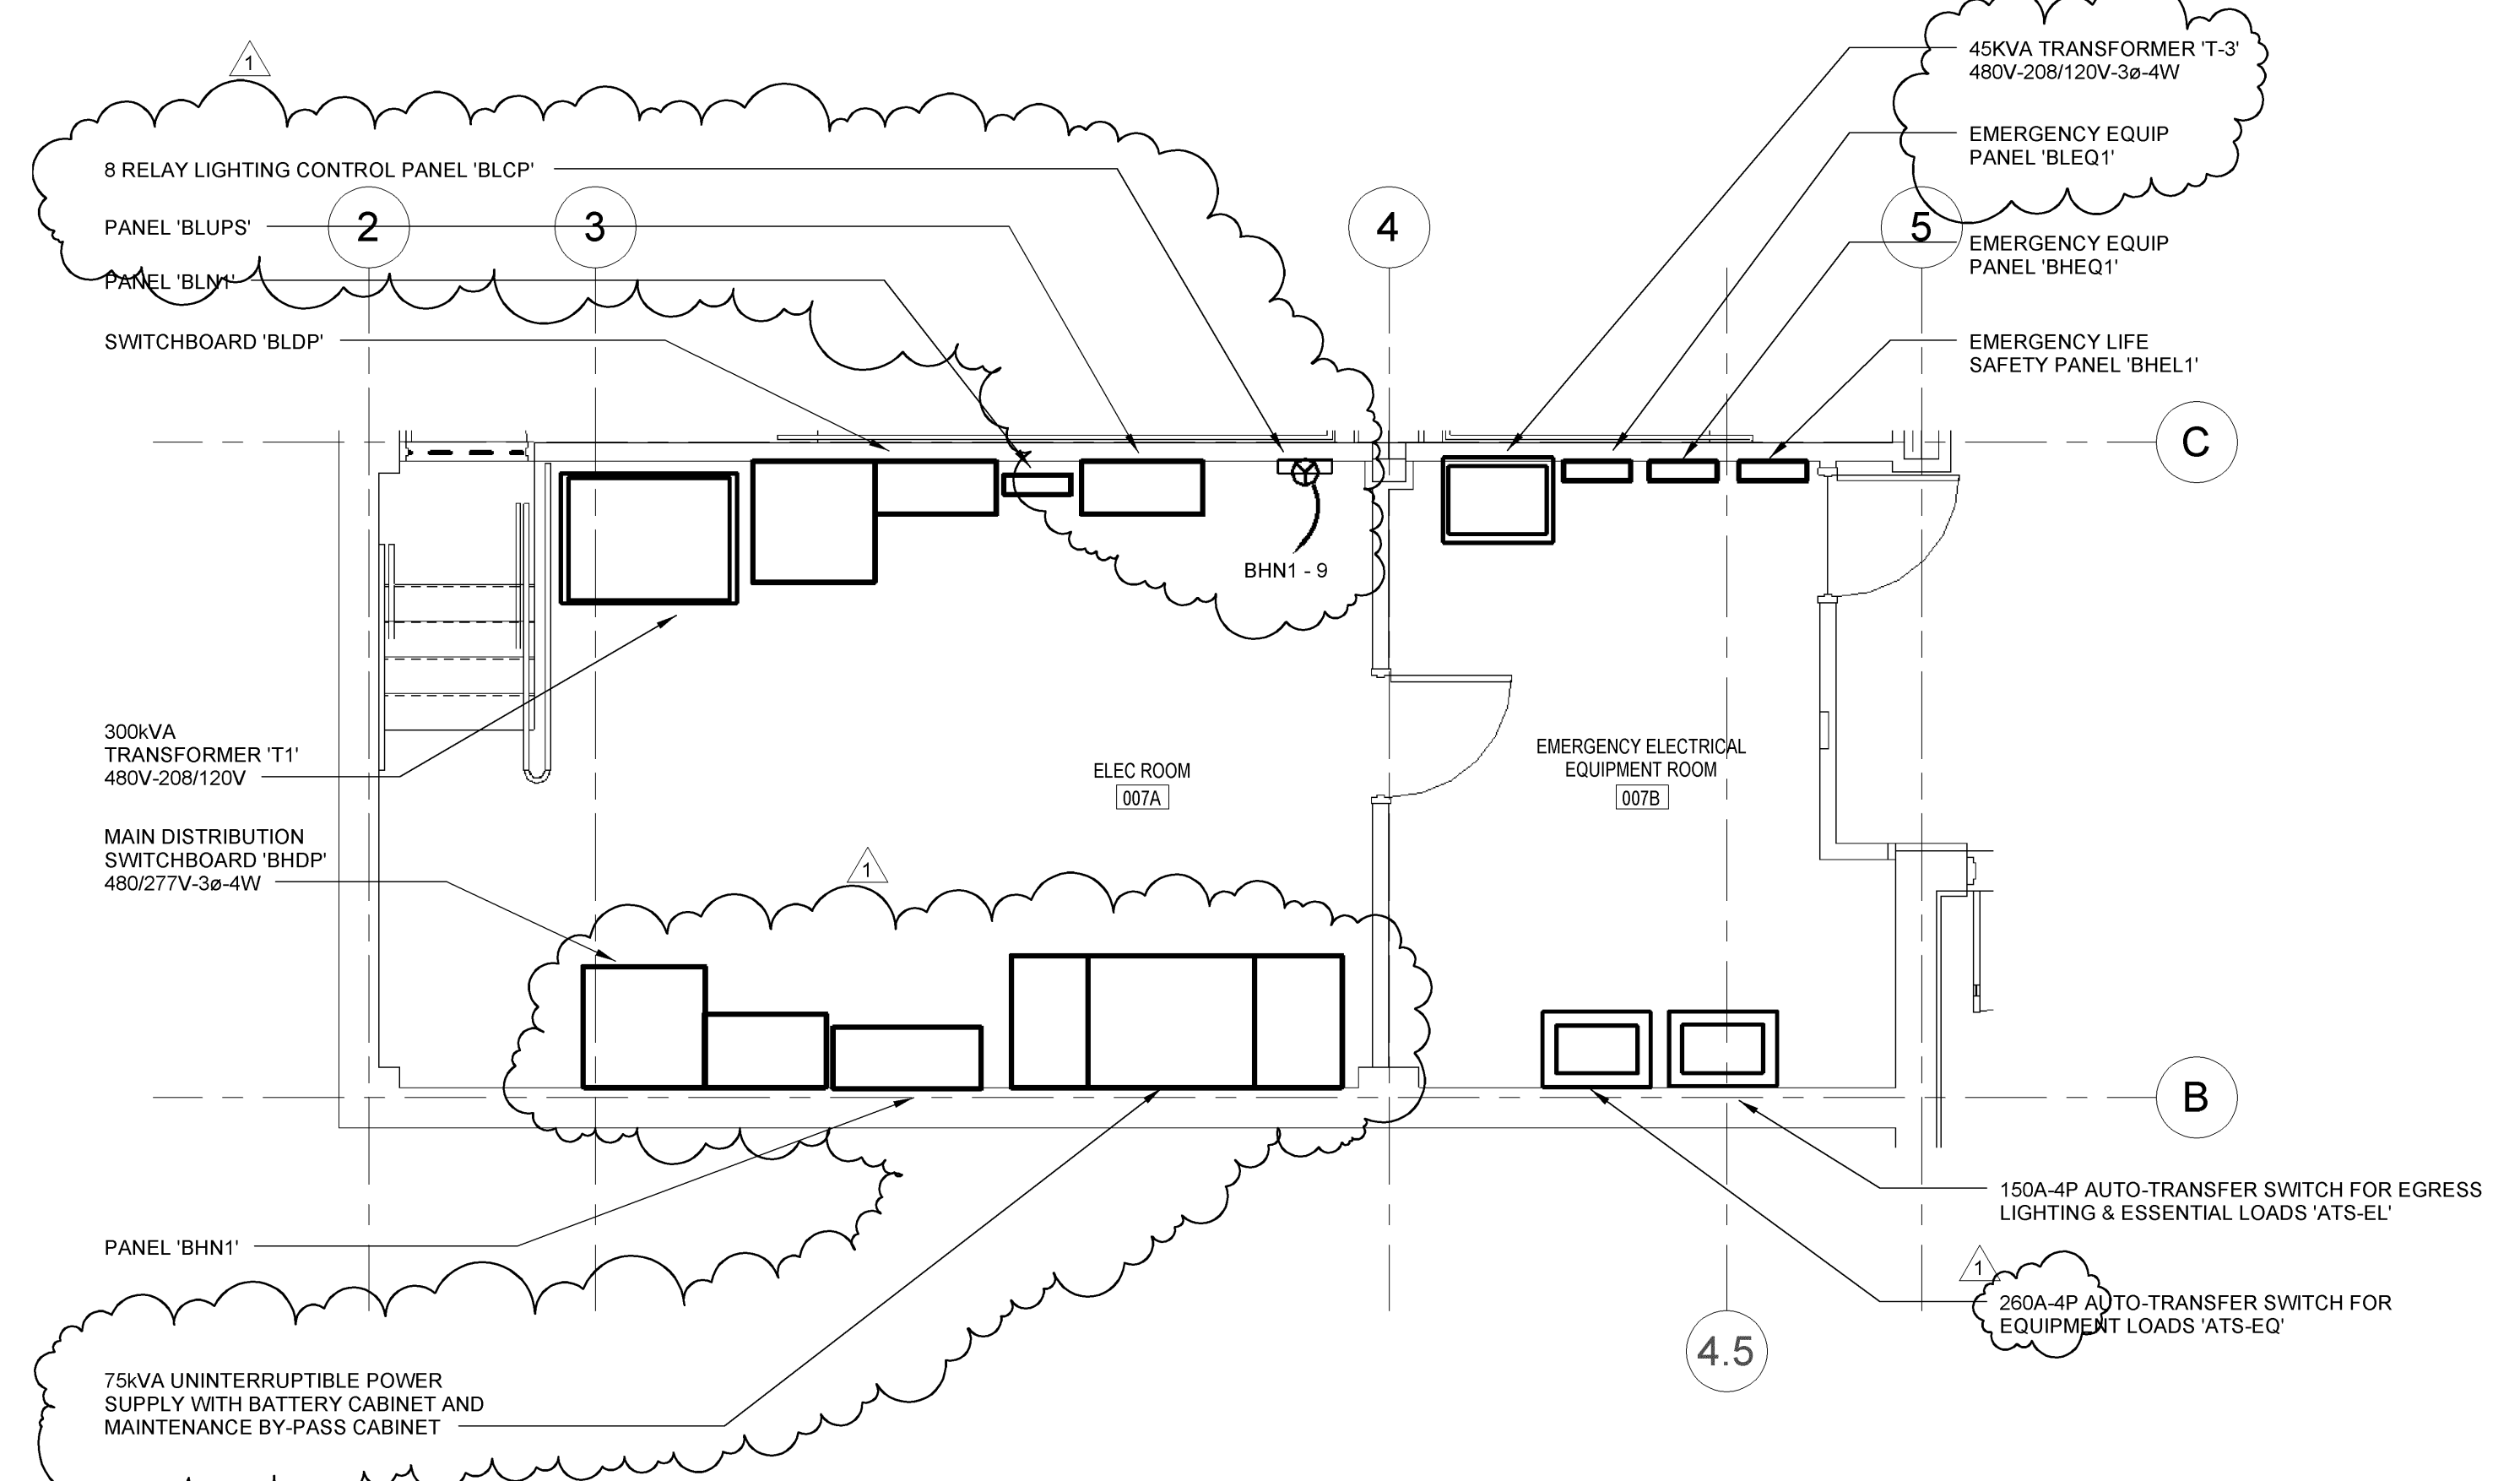


2 ENLARGED ELECTRICAL PLAN VIEW - MAIN ELECTRIC ROOM
SCALE: 1/4" = 1'-0"

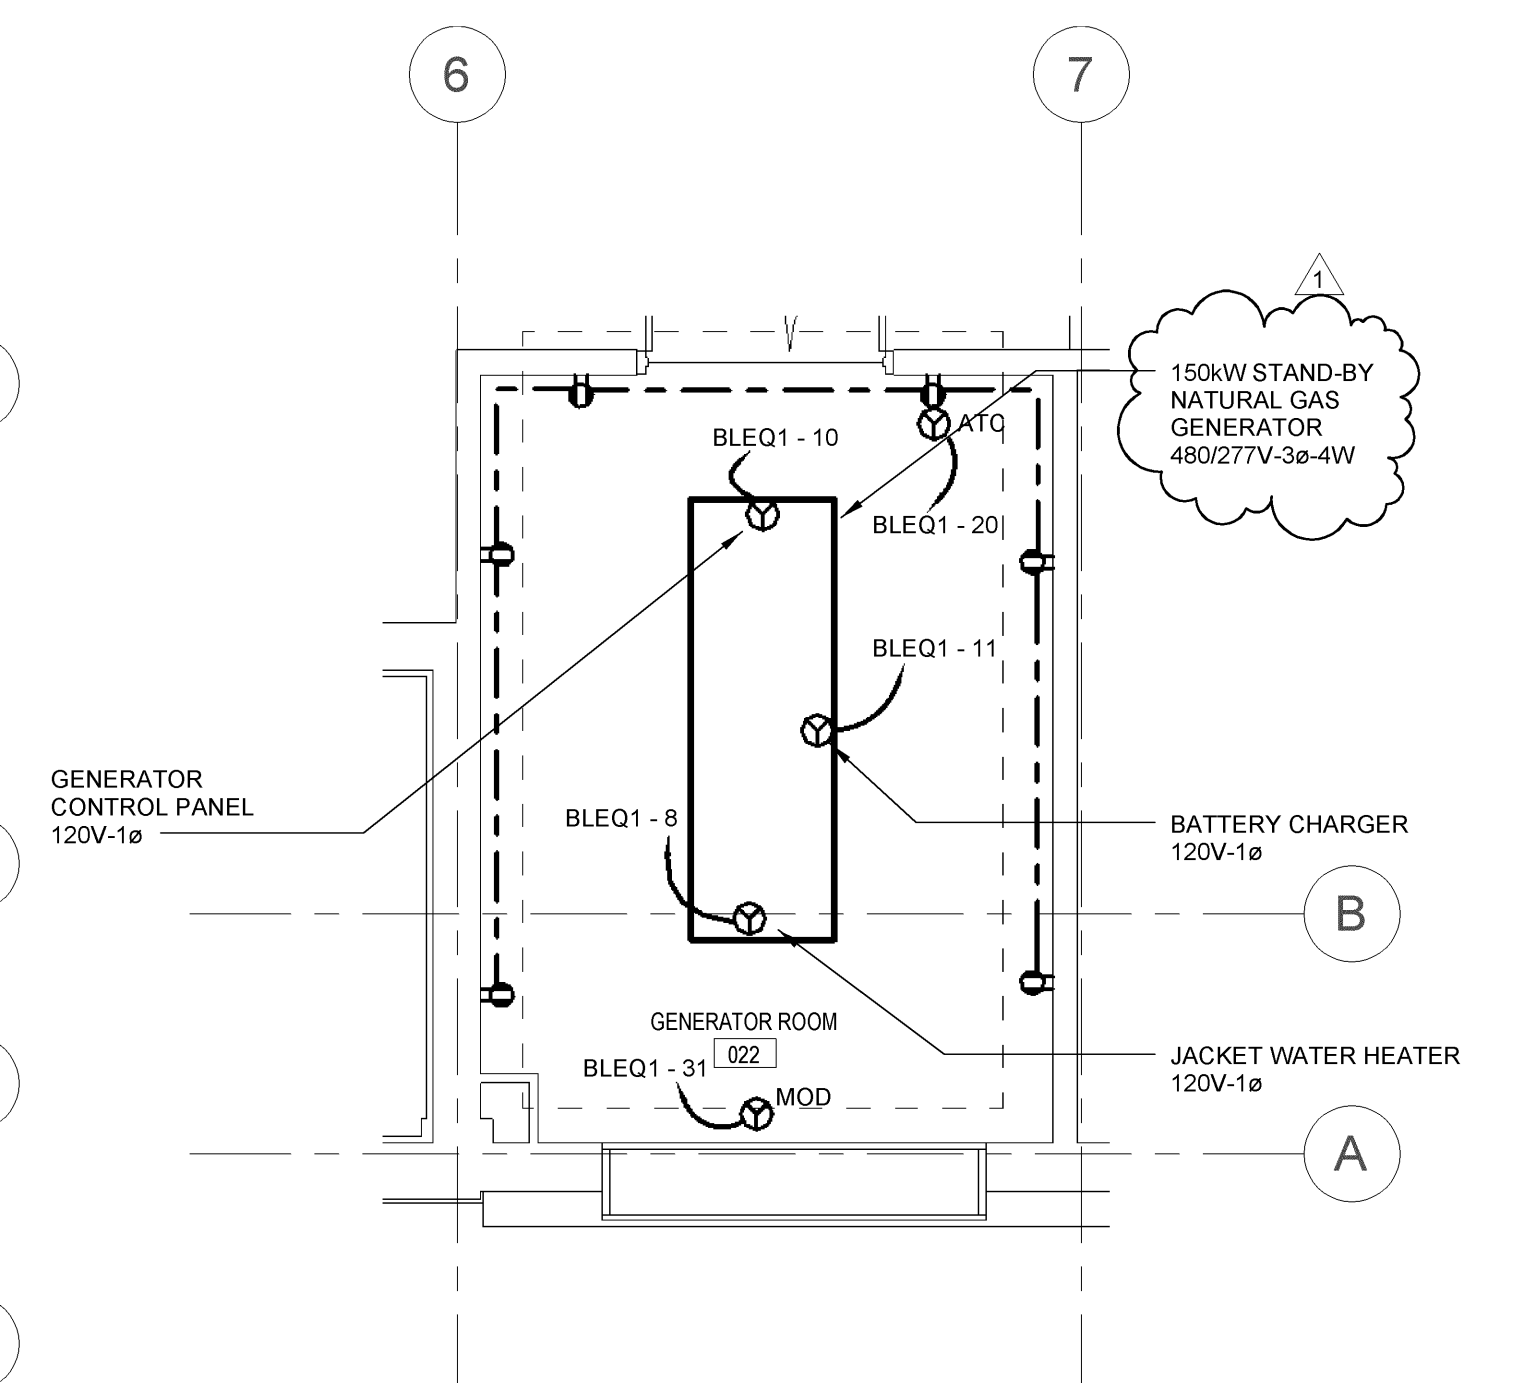

3 ENLARGED ELECTRICAL PLAN VIEW - GENERATOR ROOM
SCALE: 1/4" = 1'-0"

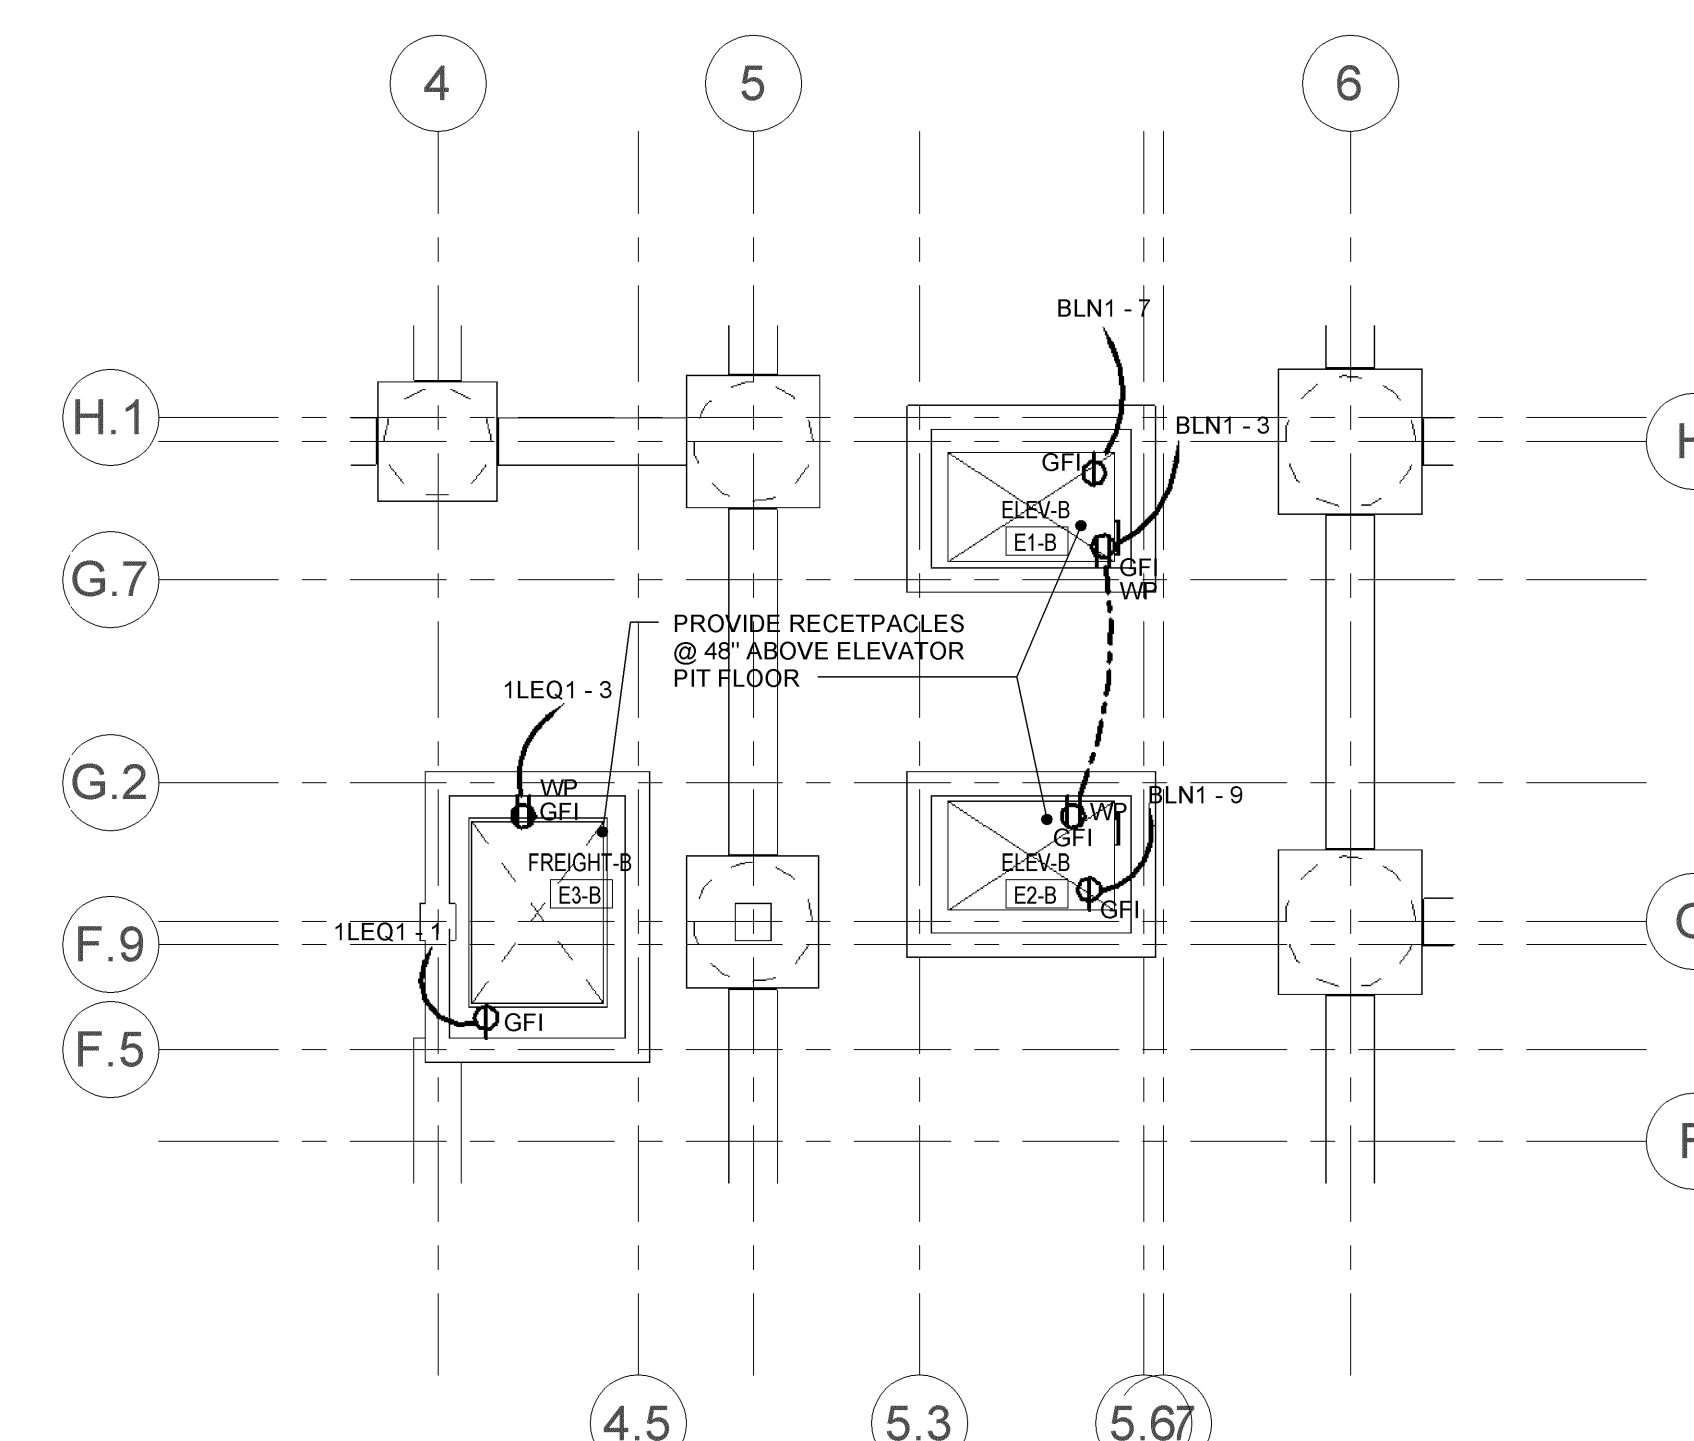

4 ELECTRICAL ELEVATOR PIT PLAN - POWER
SCALE: 1/8" = 1'-0"

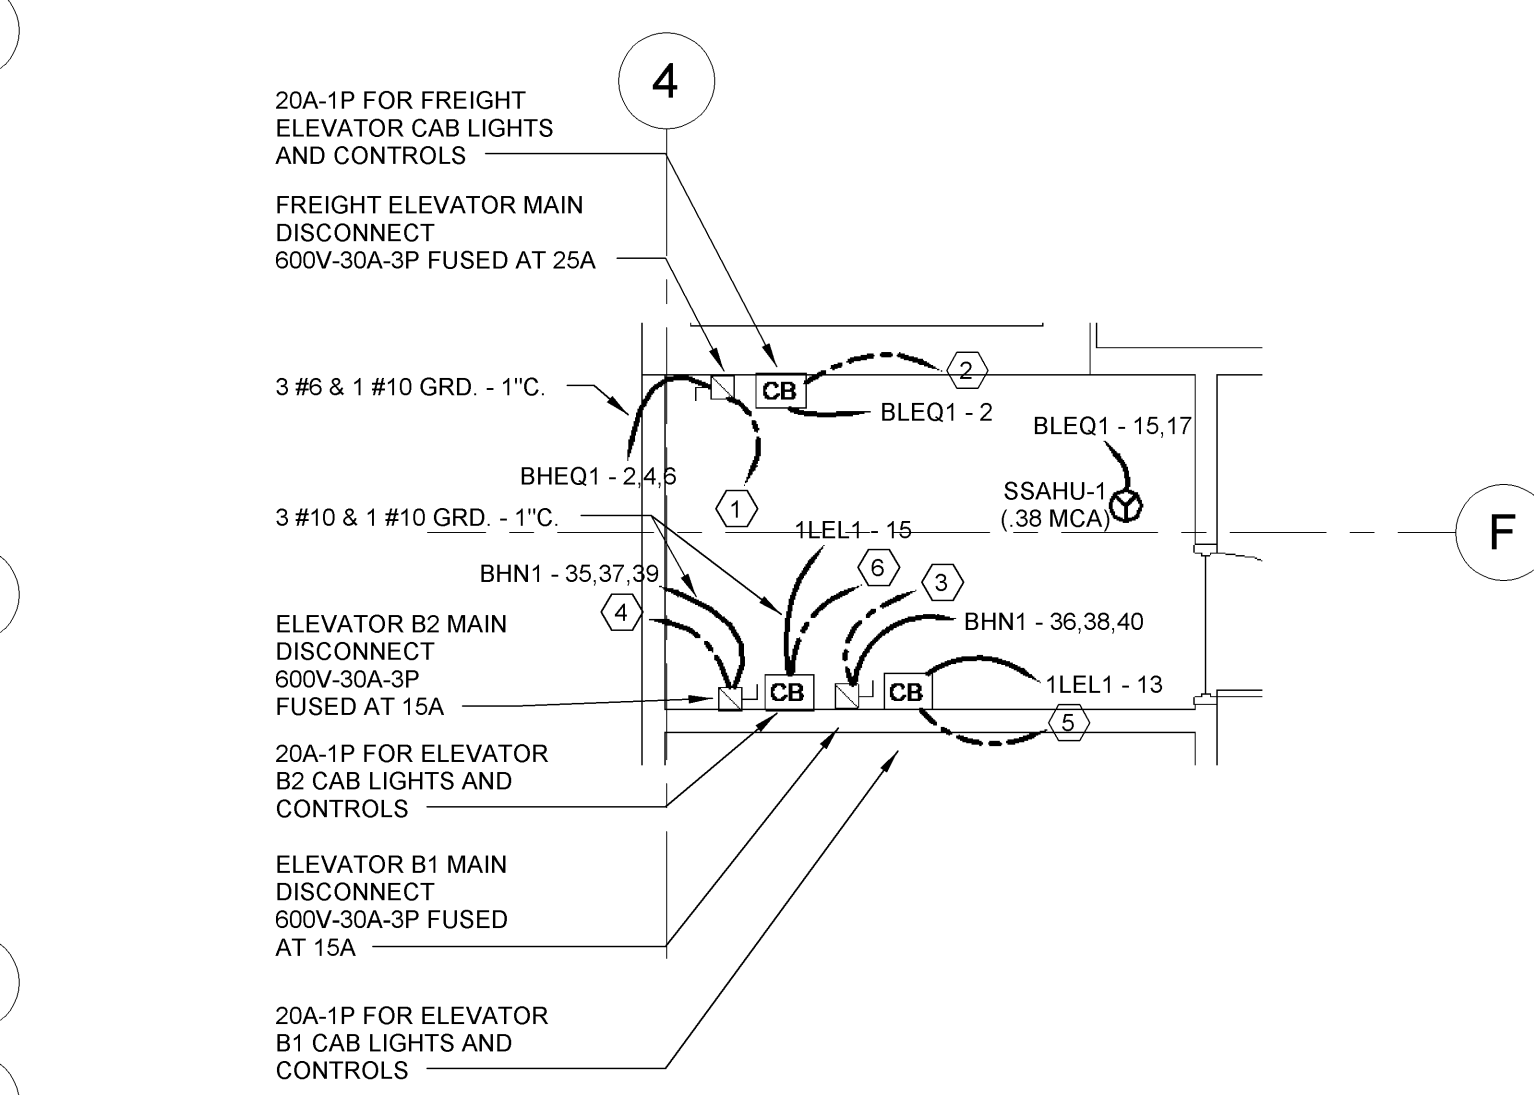

5 ENLARGED ELEVATOR MACHINE ROOM PLAN
SCALE: 1/4" = 1'-0"

○ - ELECTRICAL KEYNOTES


- 1 TO FREIGHT ELEVATOR MOTOR IN ELEVATOR SHAFT. SEE PLAN '1'.
- 2 TO CAB LIGHTS AND FAN AT FREIGHT ELEVATOR. SEE PLAN '1'.
- 3 TO ELEVATOR B1 MOTOR IN ELEVATOR SHAFT. SEE PLAN '1'.
- 4 TO ELEVATOR B2 MOTOR IN ELEVATOR SHAFT. SEE PLAN '1'.
- 5 TO CAB LIGHTS AND FAN AT ELEVATOR B1. SEE PLAN '1'.
- 6 TO CAB LIGHTS AND FAN AT ELEVATOR B2. SEE PLAN '1'.
- 7 PROVIDE BRANCH CIRCUIT TO ELEVATOR MACHINE ROOM. SEE PLAN '5' FOR ADDITIONAL INFORMATION.
- 8 1" EMT CONDUIT WITH NYLON PULLCORD. FROM BASEMENT LEVEL TO ROOF FOR TRASH CHUTE INTEGRATED DOOR POWER. PROVIDE DOUBLE GANG OUTLET BOX. IN LINE WITH CONDUIT AT EACH INTEGRATED DOOR LOCATION FROM BASEMENT TO ROOF LEVEL.
- 9 PROVIDE 1 #10 STRANDED GROUND CONDUCTOR FROM PANEL 'BLN2' TO ALL CONDUCTIVE SURFACES OF TRASH CHUTE.
- 10 3PH 480V VARIABLE FREQUENCY DRIVE FURNISHED WITH AIR HANDLER. INSTALLED BY CONTRACTOR.
- 11 3PH 480V, 7.5HP VARIABLE FREQUENCY DRIVE, FURNISHED AND INSTALLED BY CONTRACTOR.
- 12 3PH 480V, 30HP VARIABLE FREQUENCY DRIVE, FURNISHED AND INSTALLED BY CONTRACTOR.
- 13 3PH 480V, 30HP VARIABLE FREQUENCY DRIVE, FURNISHED AND INSTALLED BY CONTRACTOR.

CLARKSBURG STATE OFFICE BUILDING
 FOR
GENERAL SERVICES DIVISION
 153 WEST MAIN STREET

H.F. LENZ COMPANY
 1407 Sculp Avenue
 Johnstown, PA 15904-3329
 Phone: 814-269-9301
 FAX: 814-269-9300
 www.hflenzen.com

JOEL C. SHUMAKER
 REGISTERED PROFESSIONAL ENGINEER
 No. 1419

REVISIONS		
No.	ITEM	DATE
1		3/7/2014

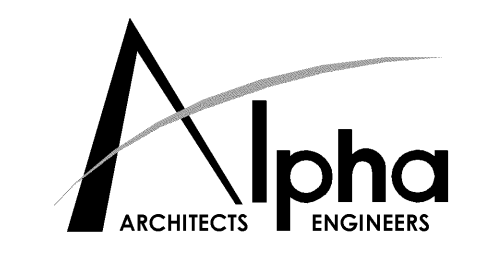

ALPHA ASSOCIATES, INC.
 209 PRAIRIE AVENUE
 MORGANTOWN, WV 26501
 PHONE/FAX: 304-276-8216
 TOLL FREE: 800-640-8216
 www.thinkALPHAtrial.com

BASEMENT FLOOR PLAN - POWER
E201

PROJ. NO.: 0810123.05
 DATE: NOVEMBER 19, 2013
 SHEET NO.:

ISSUED FOR BIDDING

C:\Revit_User_Local\MEP-2008-05\Revit-2013_1essty.rvt