



1 ELECTRICAL BASEMENT FLOOR PLAN - SIGNAL
SCALE: 1/8" = 1'-0"

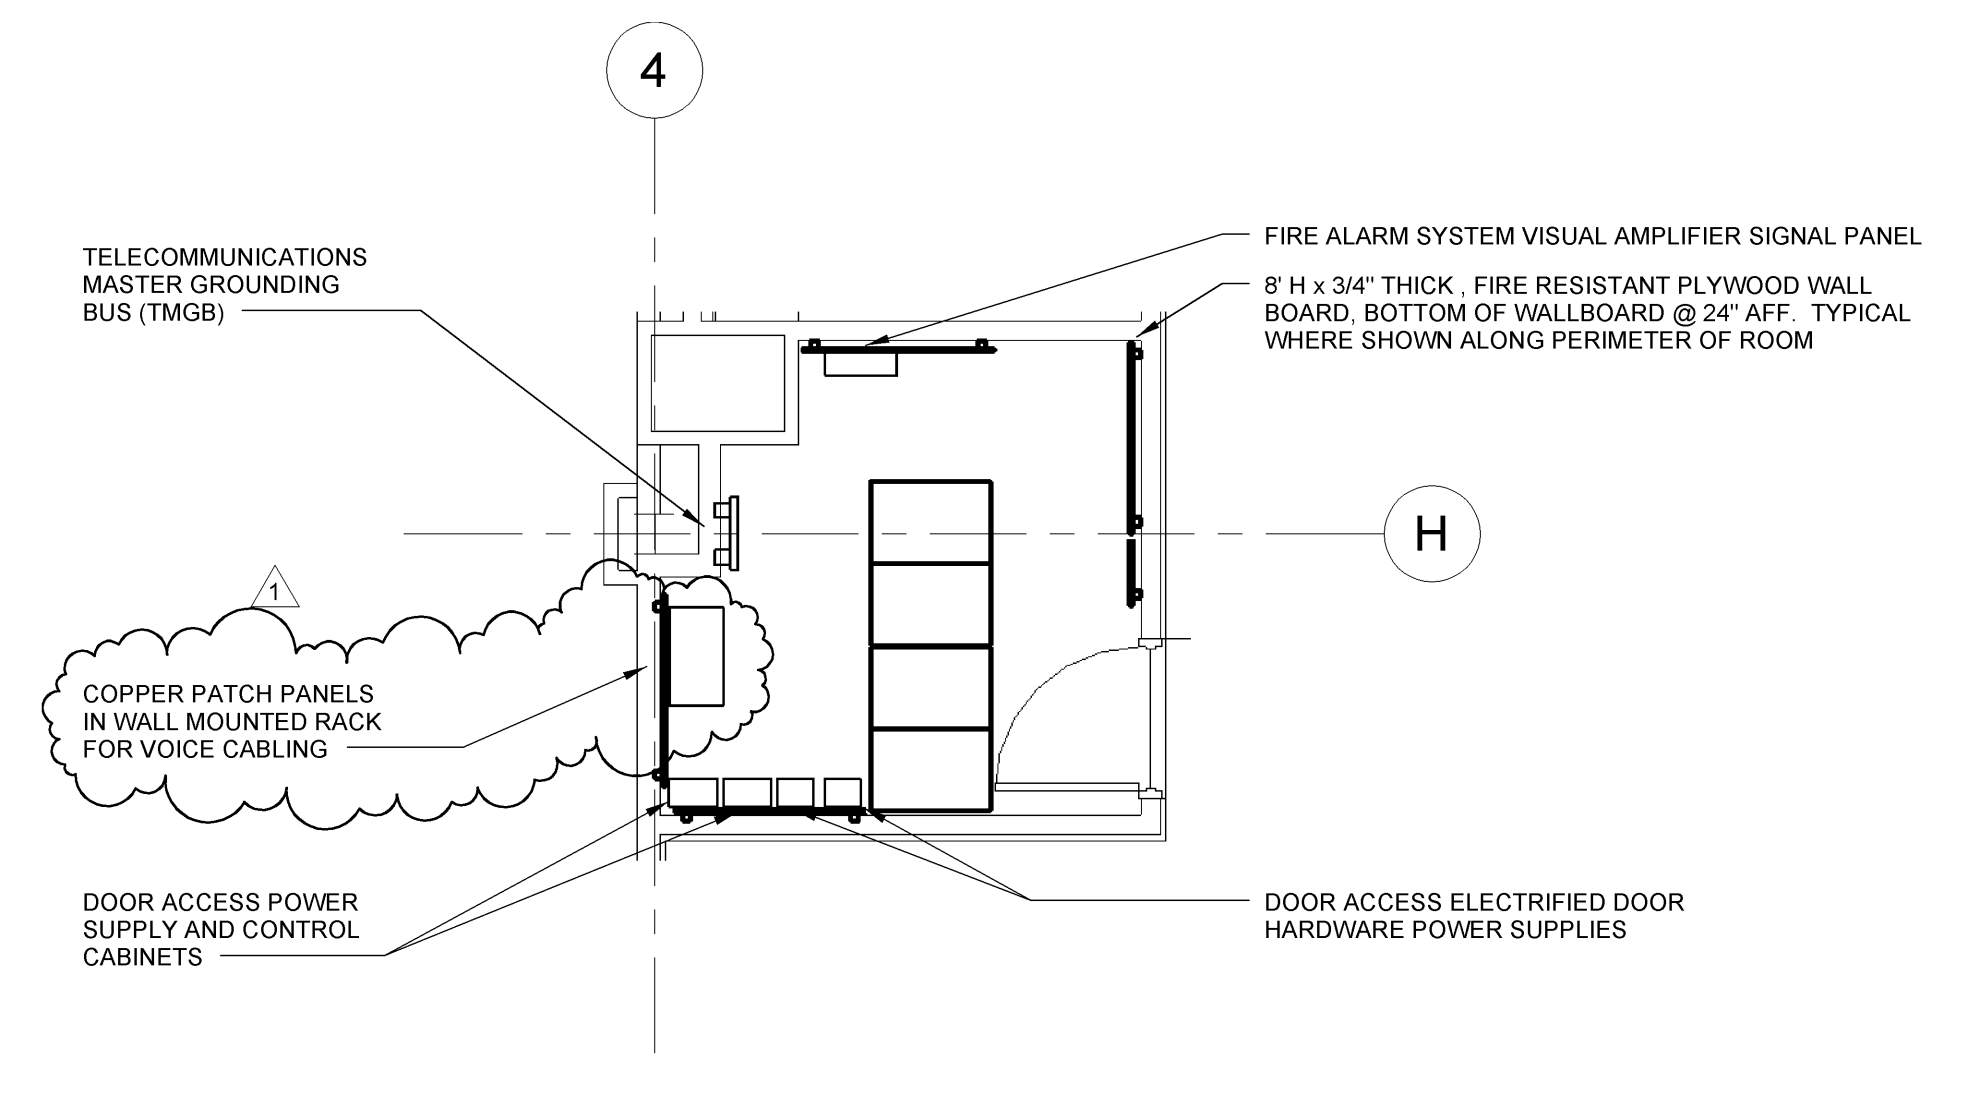

2 ENLARGED SERVICE ENTRANCE TELECOM ROOM - MDF
SCALE: 1/4" = 1'-0"

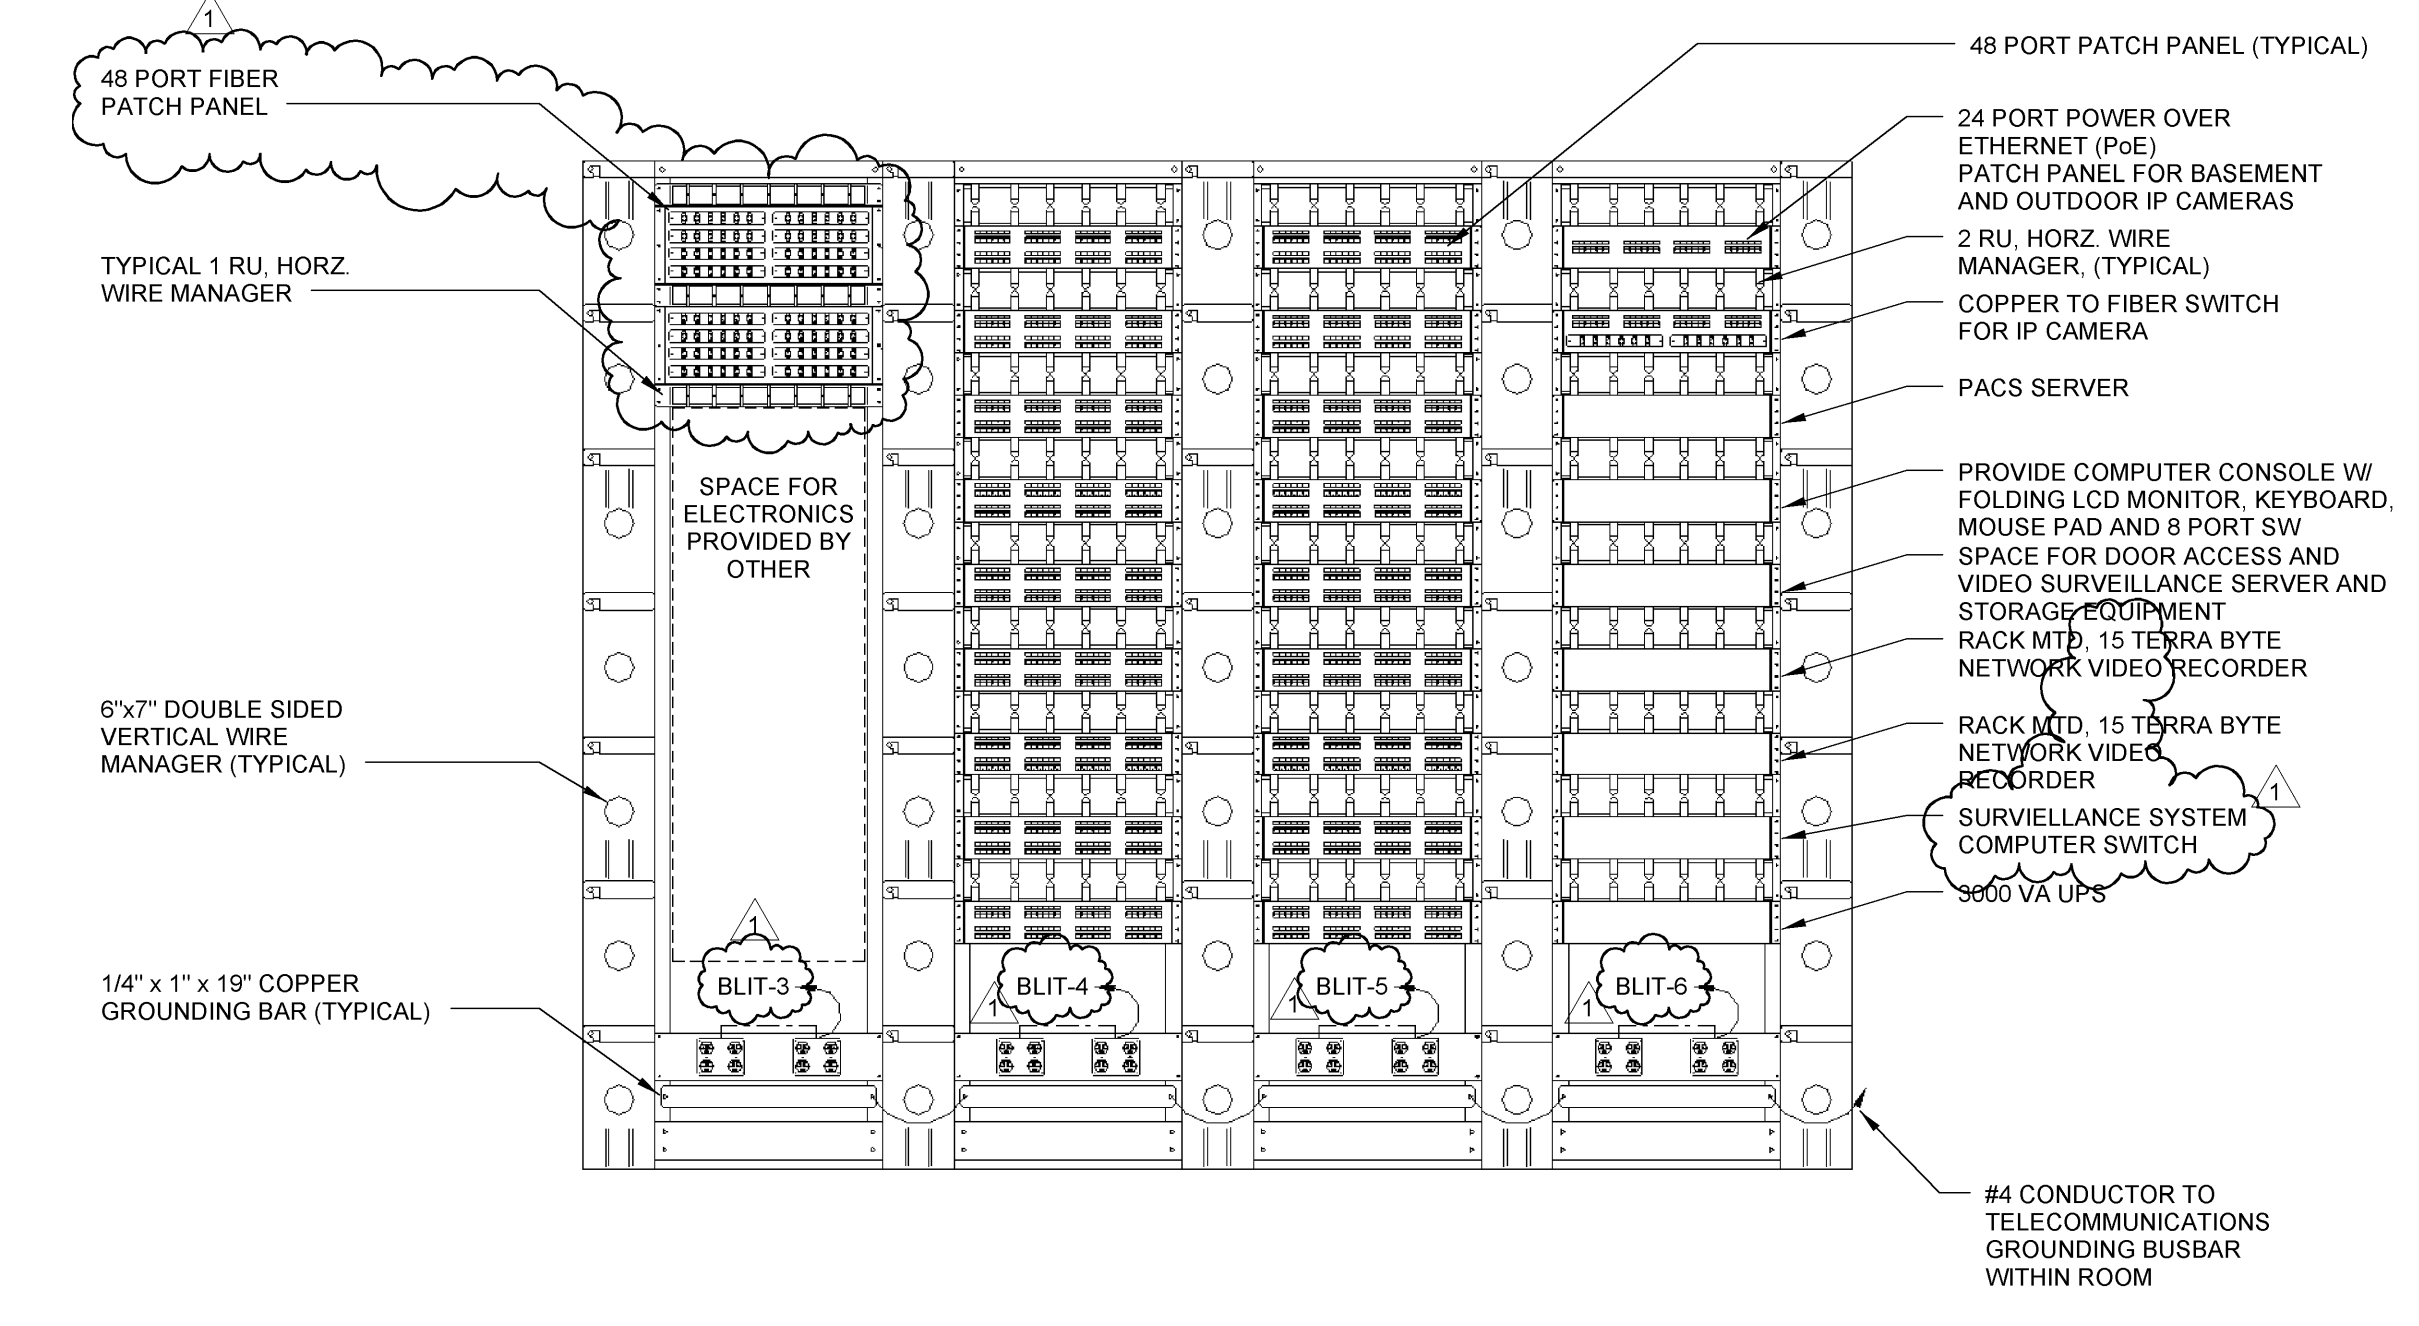


3 BASEMENT LEVEL TELECOMMUNICATION RACK ELEVATION
NOT TO SCALE

CLARKSBURG STATE OFFICE BUILDING
FOR
GENERAL SERVICES DIVISION
153 WEST MAIN STREET

H.F. LENZ COMPANY
1407 Sculp Avenue
Johnstown, PA 15904-3329
Phone: 814-269-9301
FAX: 814-269-9300
www.hflenzen.com

JOEL C. SHUMAKER
1619
STATE OF PENNSYLVANIA
PROFESSIONAL ENGINEER

REVISIONS		
No.	ITEM	DATE
1		2/7/2014

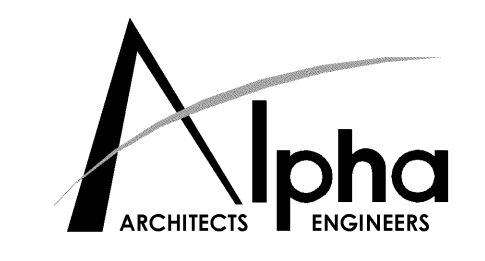

ALPHA ASSOCIATES, INC.
209 PRAIRIE AVENUE
MORGANTOWN, WV 26501
PHONE/FAX: 304-276-8216
TOLL FREE: 800-440-8216
www.thinkALPHAfirst.com

BASEMENT FLOOR PLAN - SIGNAL

PROJ. NO.: 0810123.05
DATE: NOVEMBER 19, 2013
SHEET NO.:

E301

ISSUED FOR BIDDING
2/12/2014 11:19:54 PM

C:\Revit_User_Local\MEP-2008-05\Box02-2013_1essty.rvt