



1 ELECTRICAL FIRST FLOOR PLAN - SIGNAL
SCALE: 1/8" = 1'-0"

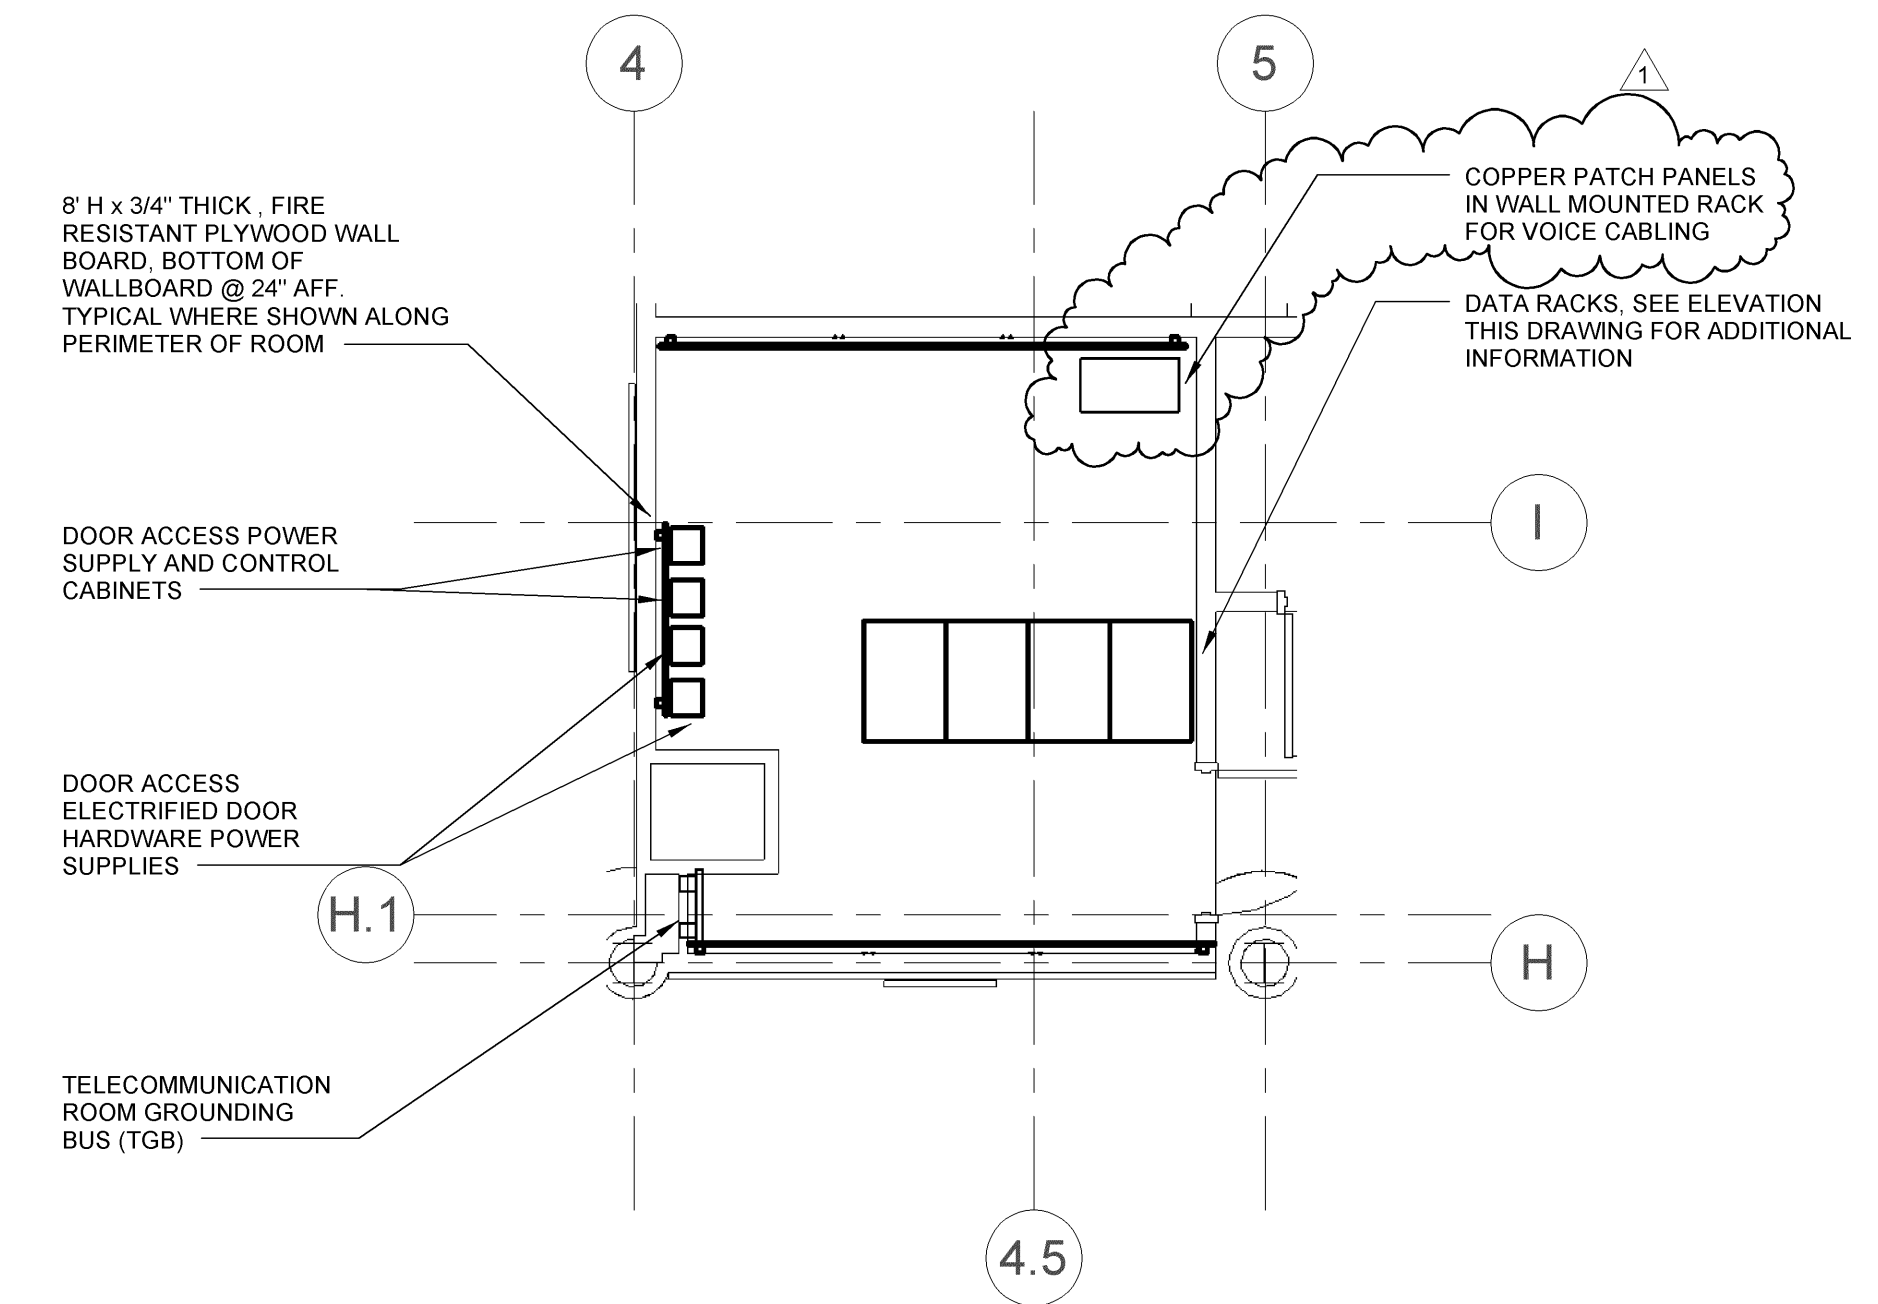


2 ENLARGED TELE/DATA ROOM FLOOR PLAN
SCALE: 1/4" = 1'-0"

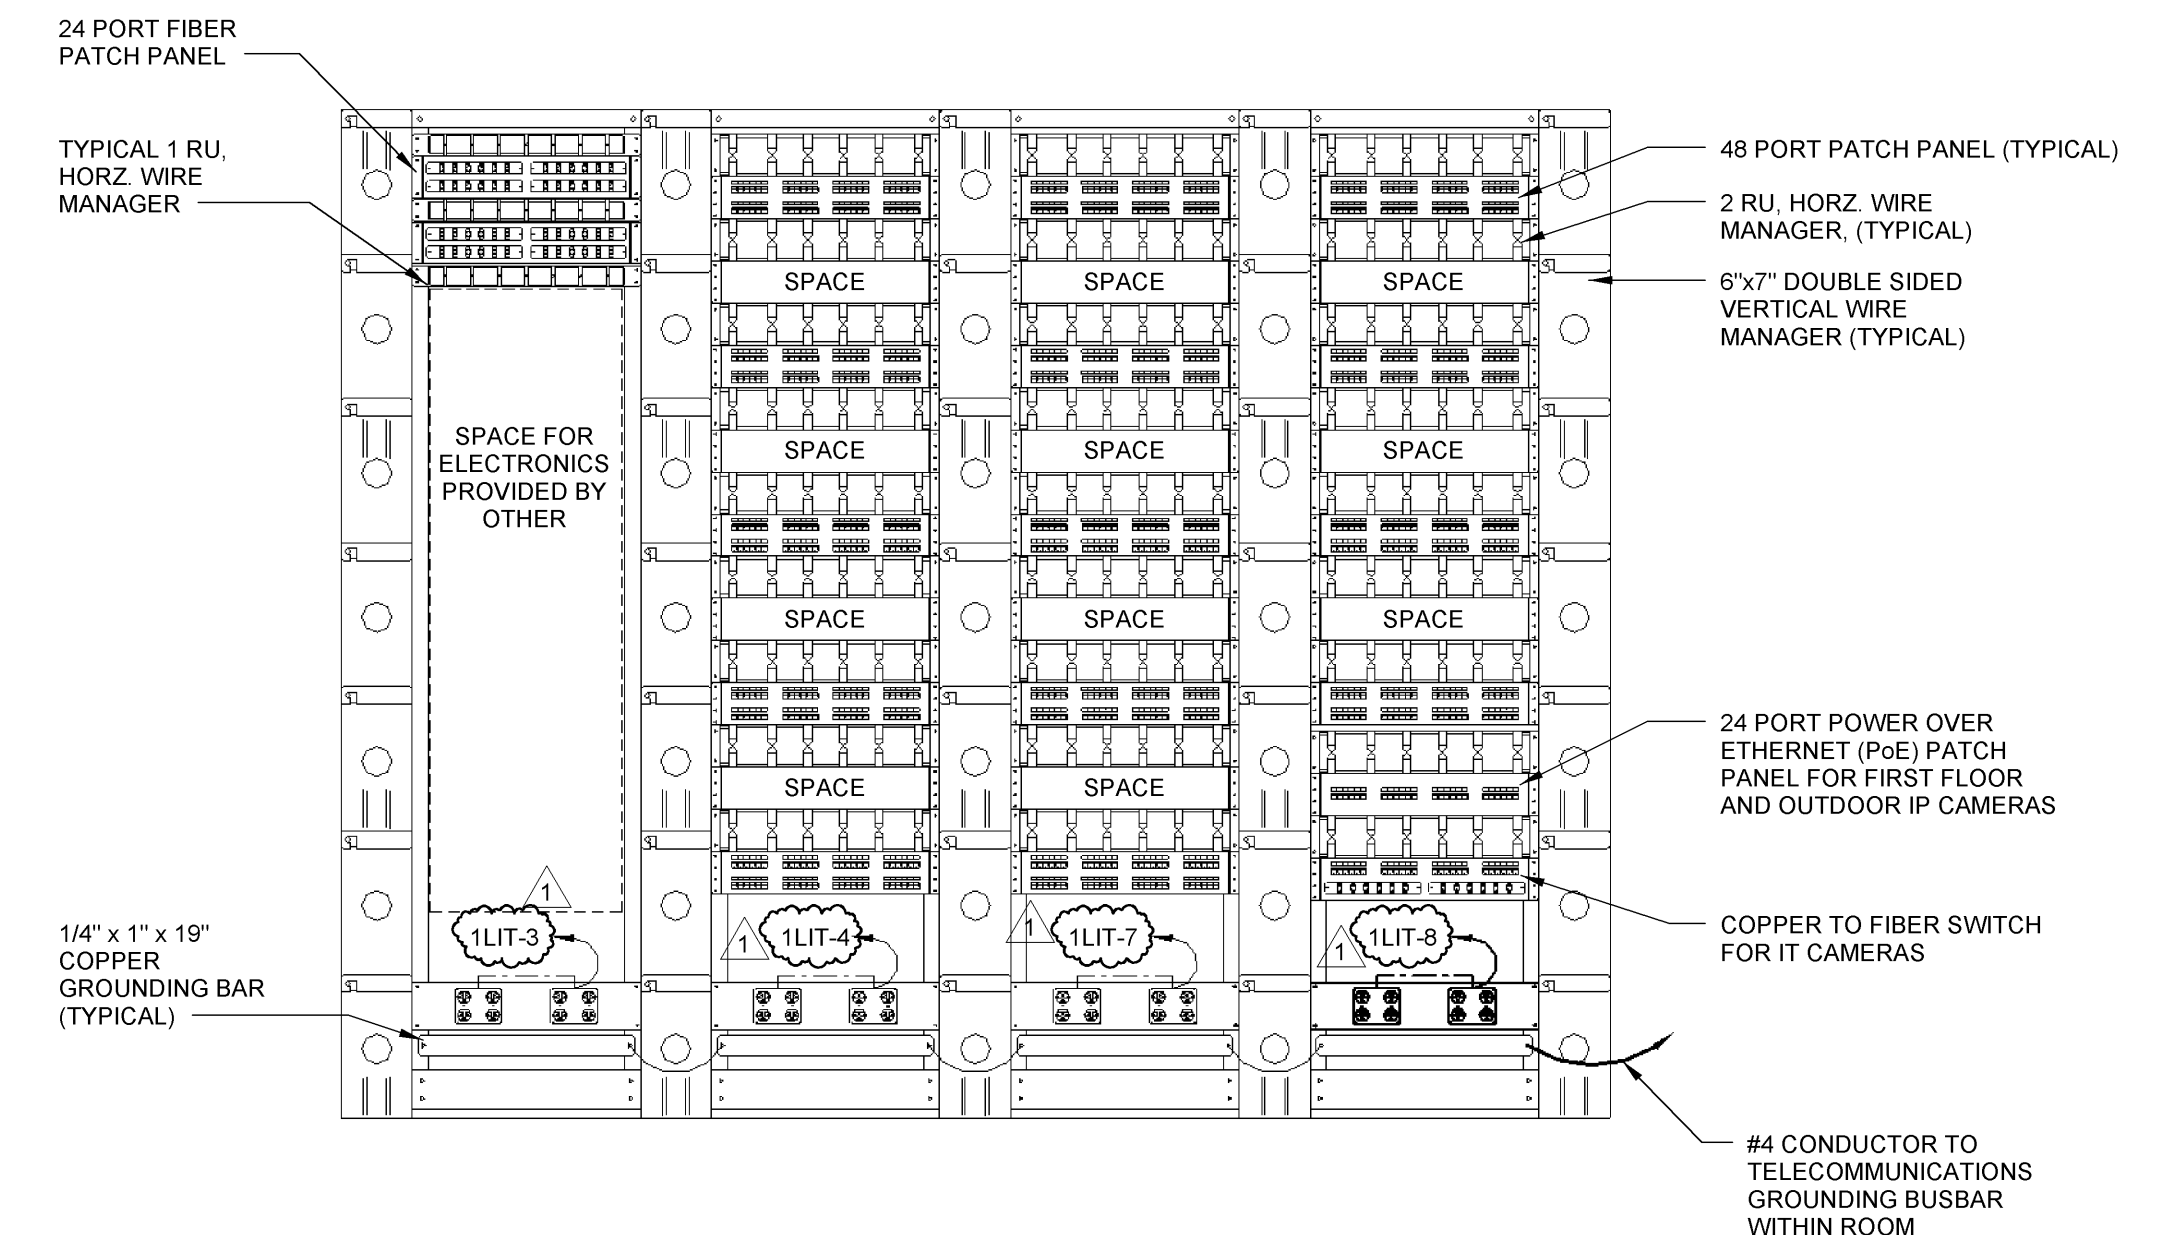

3 FIRST FLOOR TELECOMMUNICATION RACK ELEVATION
NOT TO SCALE


C:\Revit_User_Local\MEP-2008-05\Box03-2013_issy.nt

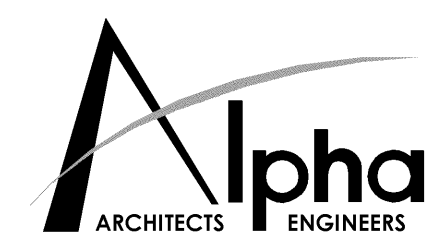

ALPHA ASSOCIATES, INC.
209 PRAIRIE AVENUE
MORGANTOWN, WV 26501
PHONE/FAX: 304-276-8216
TOLL FREE: 800-640-8216
WWW.ALPHAINC.COM

CLARKSBURG STATE OFFICE BUILDING
FOR
GENERAL SERVICES DIVISION
153 WEST MAIN STREET

H.F. LENZ
COMPANY
1407 Sculp Avenue
Johnstown, PA 15904-3329
Phone: 814-249-9301
FAX: 814-249-9300
www.hflenzen.com

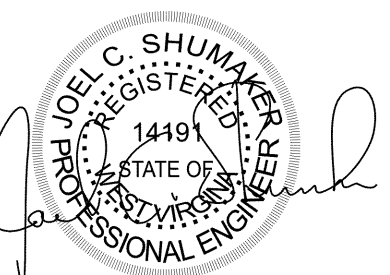

REVISIONS		
No.	ITEM	DATE
1		2/7/2014

PROJ. NO.: 0810123.05
DATE: NOVEMBER 19, 2013
SHEET NO.:

E302

ISSUED FOR BIDDING
2/12/2014 1:20:35 PM