



1 ELECTRICAL THIRD FLOOR PLAN - SIGNAL
SCALE: 1/8" = 1'-0"

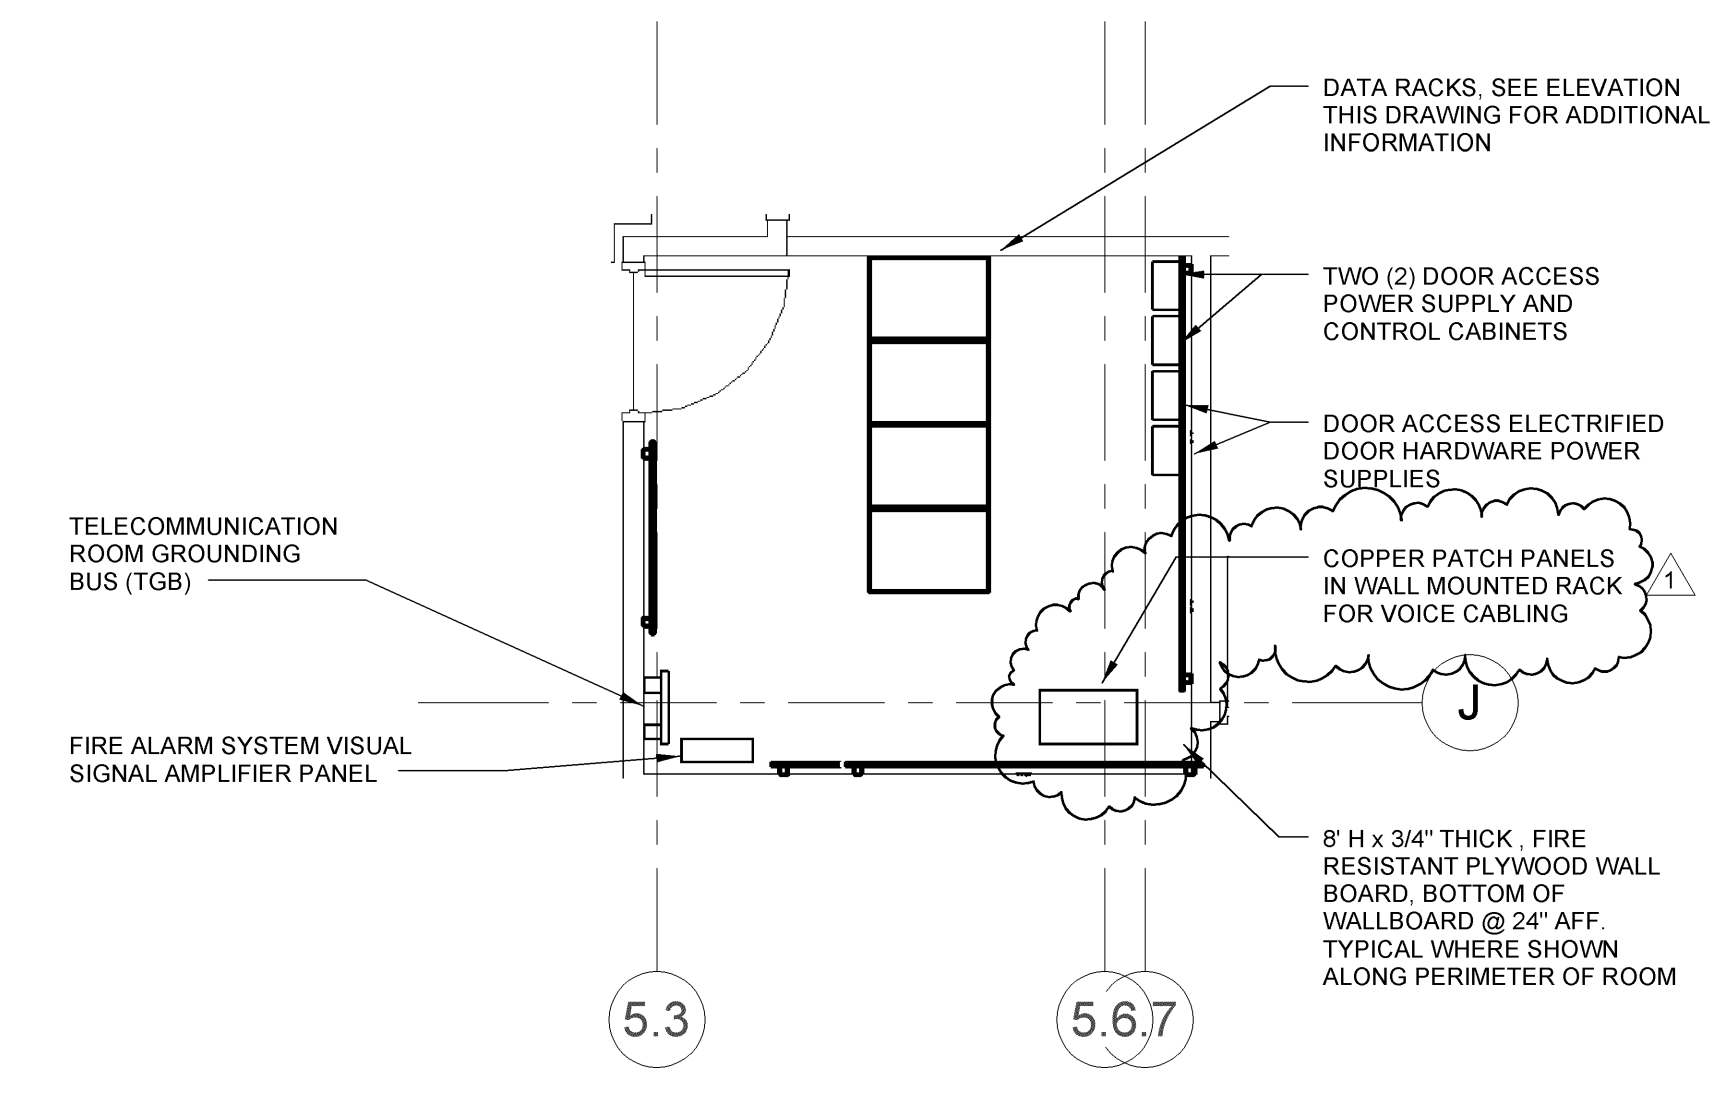

2 Callout of TELEDATA ROOM 302
SCALE: 1/4" = 1'-0"

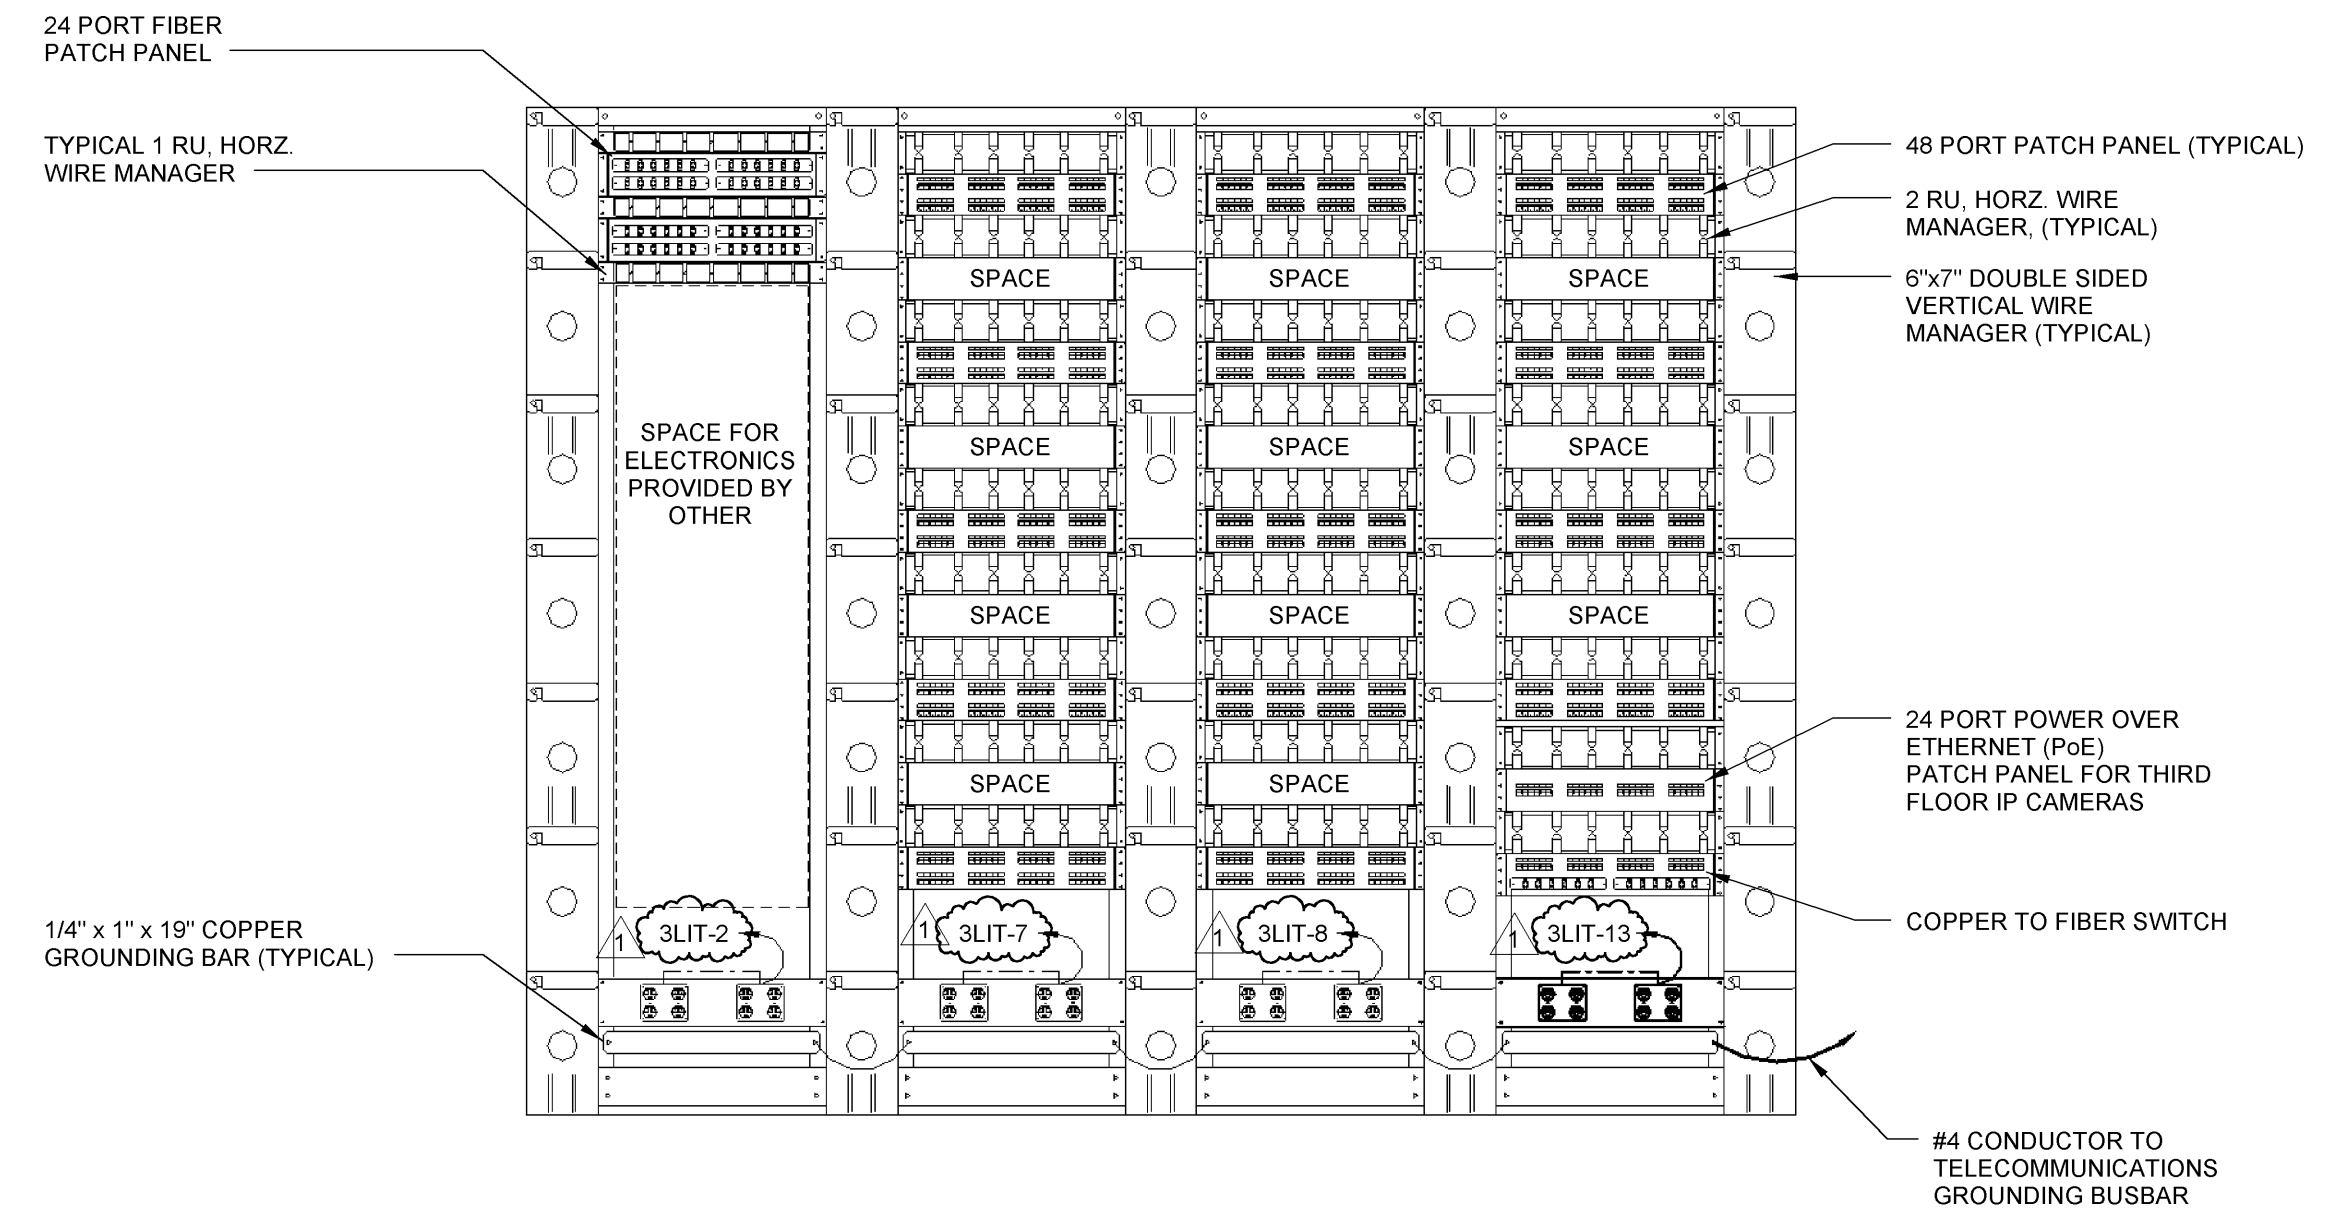

3 THIRD FLOOR TELECOMMUNICATION RACK ELEVATION
NOT TO SCALE


CLARKSBURG STATE OFFICE BUILDING
FOR
GENERAL SERVICES DIVISION
153 WEST MAIN STREET

H.F. LENZ COMPANY
1407 Scalp Avenue
Johnstown, PA 15904-3329
Phone: 814-249-9301
FAX: 814-249-9300
www.hflenz.com

JOEL C. SHUMAKER
Professional Engineer
No. 1419

COPYRIGHT © 2013 ALPHA ASSOCIATES, INC. ALL RIGHTS RESERVED.

REVISIONS		
No.	ITEM	DATE
1		2/7/2014

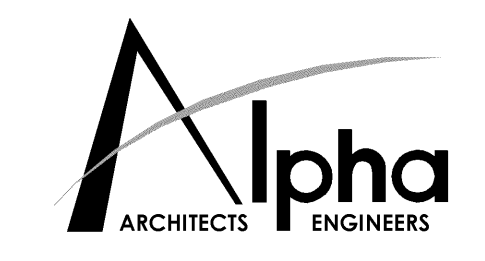

ALPHA ASSOCIATES, INC.
209 PRAIRIE AVENUE
MORGANTOWN, WV 26501
PHONE/FAX: 304-276-8216
TOLL FREE: 800-640-8216
www.thinkALPHAfirst.com

THIRD FLOOR PLAN - SIGNAL

PROJ. NO.: 0810123.05
DATE: NOVEMBER 19, 2013
SHEET NO.:

E304

ISSUED FOR BIDDING

C:\Revit_User_Local\MEP-2008-05\Fac03-2013_1essty.rvt

2/12/2014 1:21:51 PM