


2 ENLARGED TELE/DATA ROOM FLOOR PLAN  
SCALE: 1/4" = 1'-0"

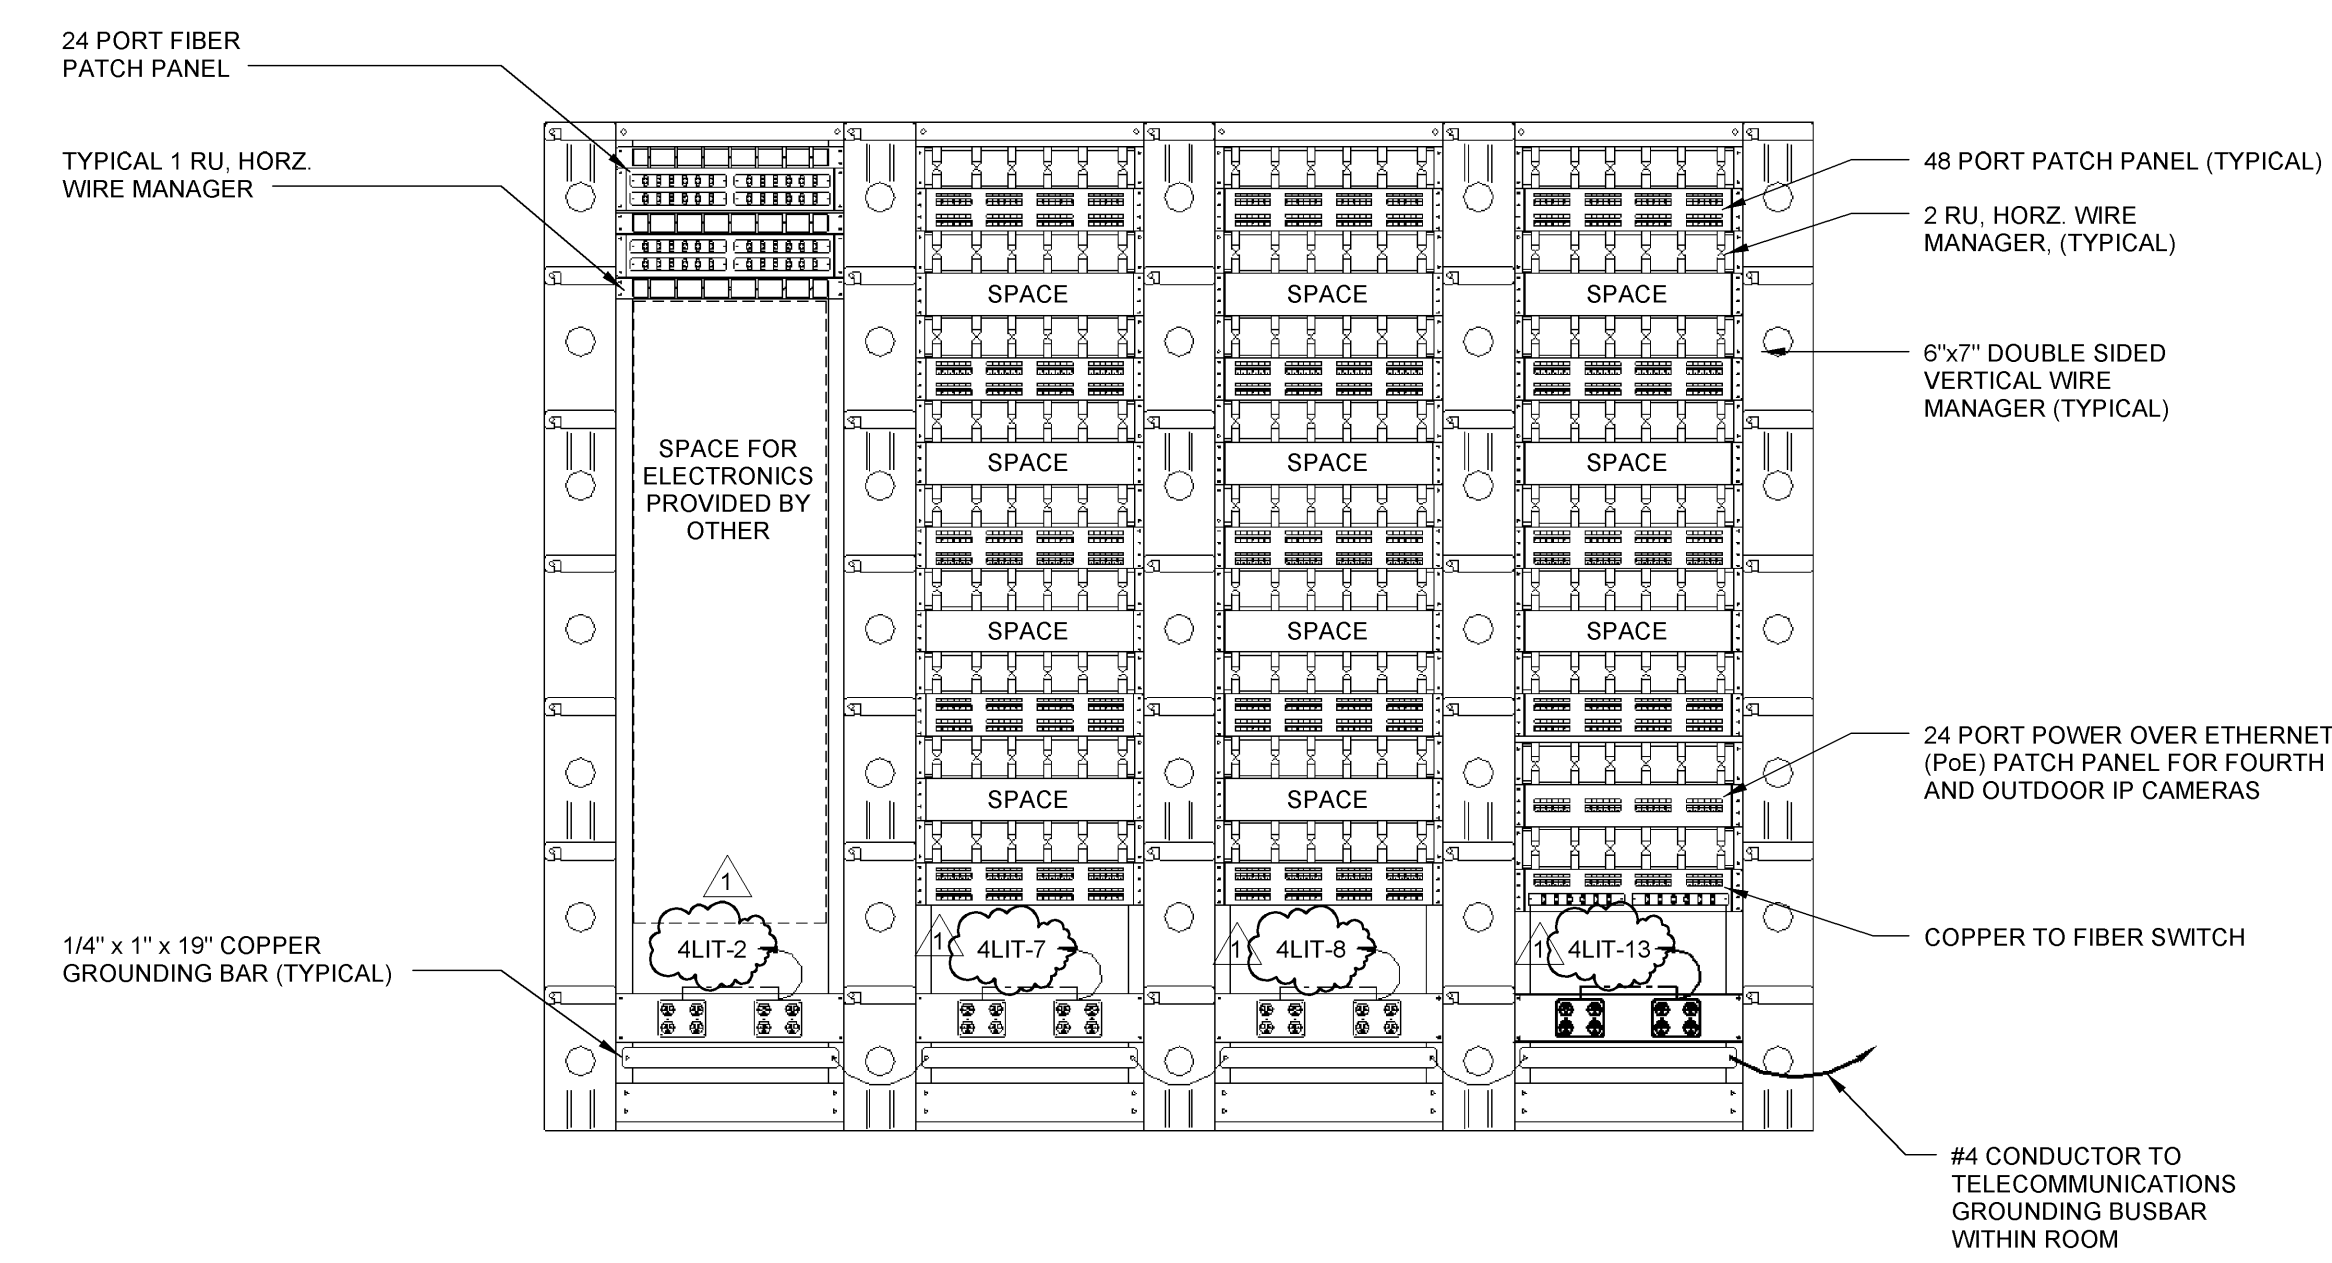

3 FOURTH FLOOR TELECOMMUNICATION RACK ELEVATION  
NOT TO SCALE

CLARKSBURG STATE OFFICE BUILDING  
FOR  
GENERAL SERVICES DIVISION  
153 WEST MAIN STREET

**H.F. LENZ COMPANY**  
1407 Sculp Avenue  
Johnstown, PA 15904-3329  
Phone: 814-269-9301  
FAX: 814-269-9300  
www.hflenz.com

JOEL C. SHUMAKER  
1419  
STATE OF PENNSYLVANIA  
PROFESSIONAL ENGINEER

REVISIONS		
No.	ITEM	DATE
1		3/7/2014



ALPHA ASSOCIATES, INC.  
209 PRAIRIE AVENUE  
MORGANTOWN, WV 26501  
PHONE/FAX: 304-276-8216  
TOLL FREE: 800-440-8216  
www.thinkALPHAtrial.com

FOURTH FLOOR PLAN -  
SIGNAL

PROJ. NO.: 0810123.05  
DATE: NOVEMBER 19, 2013  
SHEET NO.:

**E305**

ISSUED FOR BIDDING