


**1 ELECTRICAL BASEMENT FLOOR PLAN - LIGHTING**  
SCALE: 1/8" = 1'-0"

**○ - ELECTRICAL KEYNOTES**

1 COORDINATE FINAL LOCATION OF TYPE WMF1 FIXTURES IN ELEVATOR SHAFT WITH ELEVATOR INSTALLER

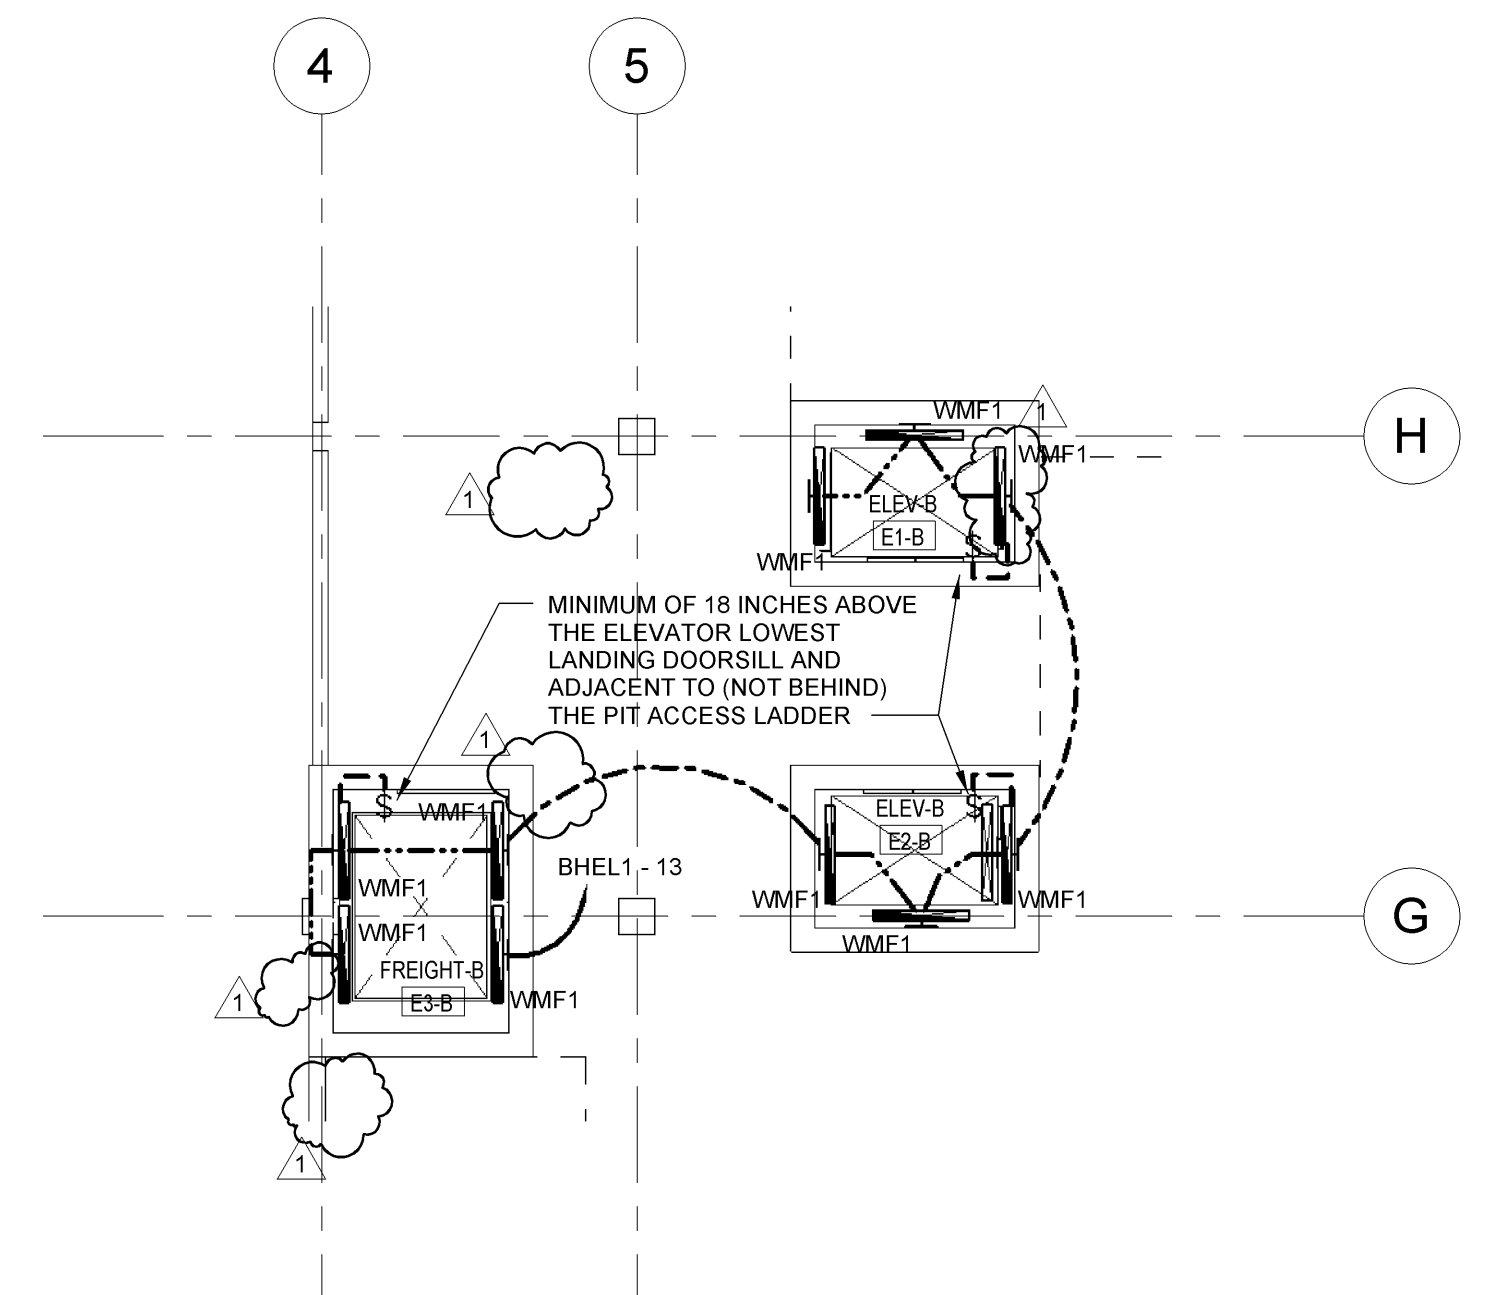


**2 ELECTRICAL ELEVATOR PIT PLAN - LIGHTING**  
SCALE: 1/8" = 1'-0"

C:\Revit\_User\_Local\MEP-2008-05\Revit-2013\_1essty.rvt

**CLARKSBURG STATE OFFICE BUILDING**  
FOR  
**GENERAL SERVICES DIVISION**  
153 WEST MAIN STREET

**H.F. LENZ COMPANY**  
1407 Sculp Avenue  
Johnstown, PA 15904-3329  
Phone: 814-269-9301  
FAX: 814-269-9300  
www.hflenz.com

JOEL C. SHUMAKER  
1419  
STATE OF PENNSYLVANIA  
PROFESSIONAL ENGINEER

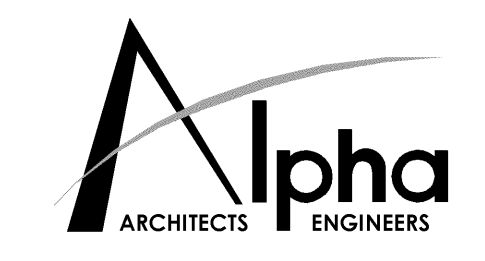

ALPHA ASSOCIATES, INC.  
209 PRAIRIE AVENUE  
MORGANTOWN, WV 26501  
PHONE/FAX: 304-276-8216  
TOLL FREE: 800-640-8216  
www.thinkALPHAfirst.com

**BASEMENT FLOOR PLANS - LIGHTING**

REVISIONS		
No.	ITEM	DATE
1		2/7/2014

PROJ. NO.: 0810123.05  
DATE: NOVEMBER 19, 2013  
SHEET NO.:

**E101**

ISSUED FOR BIDDING  
2/12/2014 11:52:20 AM